


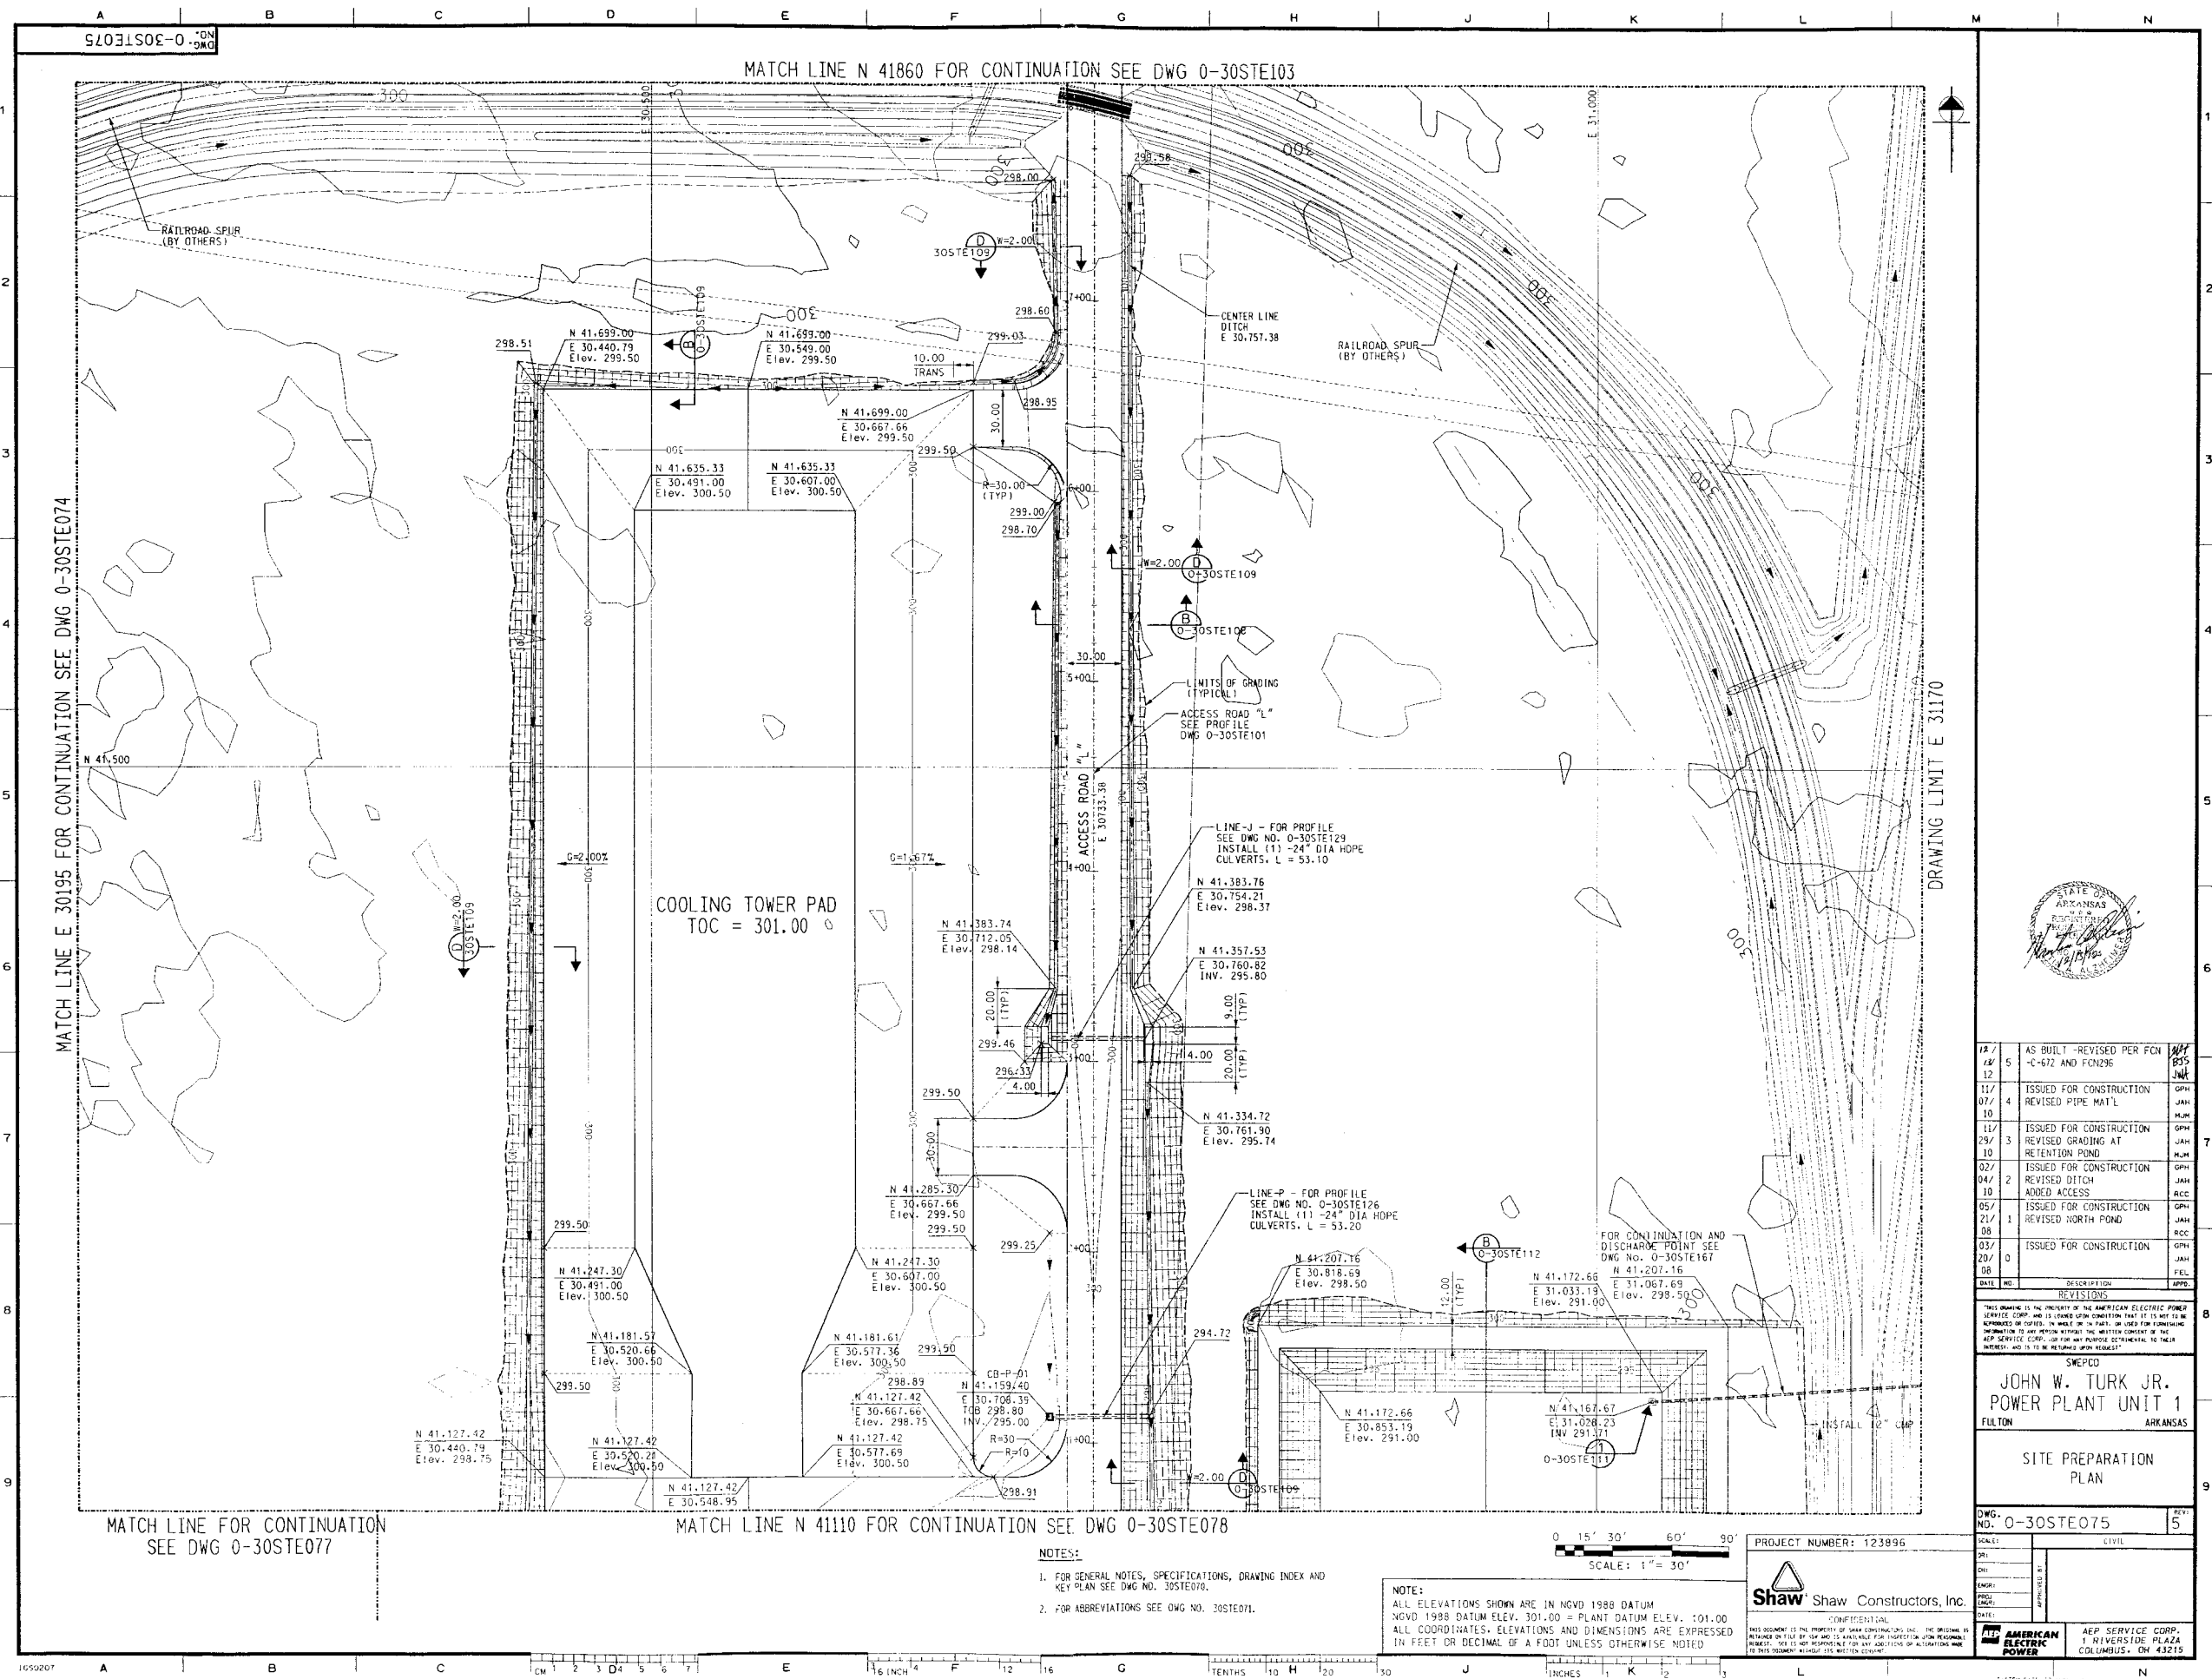



DATE	NO.	DESCRIPTION	APPROVED
12/12/12	5	AS BUILT - REVISED PER FCN "C-612 AND F0296"	JWT
11/07/10	4	ISSUED FOR CONSTRUCTION REVISED PIPE MAT'L	GMH
11/29/10	3	ISSUED FOR CONSTRUCTION REVISED GRADING AT RETENTION POND	GMH
02/04/10	2	ISSUED FOR CONSTRUCTION REVISED DITCH ADDED ACCESS	GMH
05/21/08	1	ISSUED FOR CONSTRUCTION REVISED NORTH POND	GMH
03/20/08	0	ISSUED FOR CONSTRUCTION	GMH

SWEPCO
JOHN W. TURK JR.
POWER PLANT UNIT 1
FULTON, ARKANSAS

SITE PREPARATION
PLAN

DWG. NO. 0-30STE075

SCALE:	CIVIL
DATE:	
BY:	
CHK:	
ENGR:	
PROJ. ENGR.:	
DATE:	

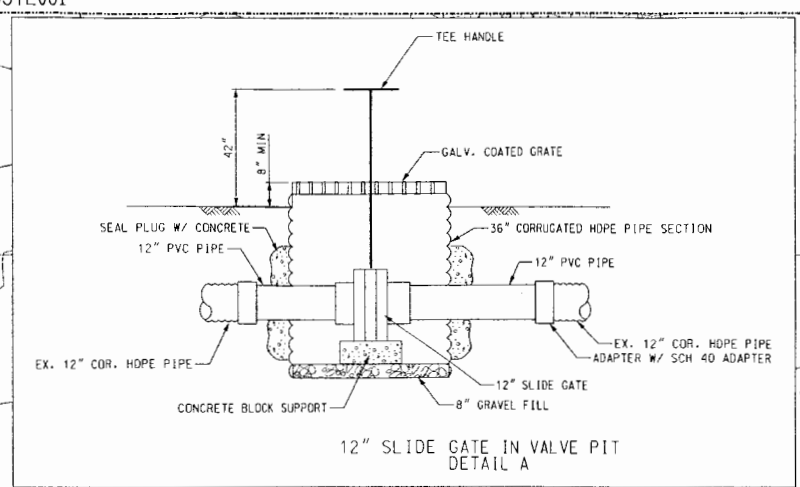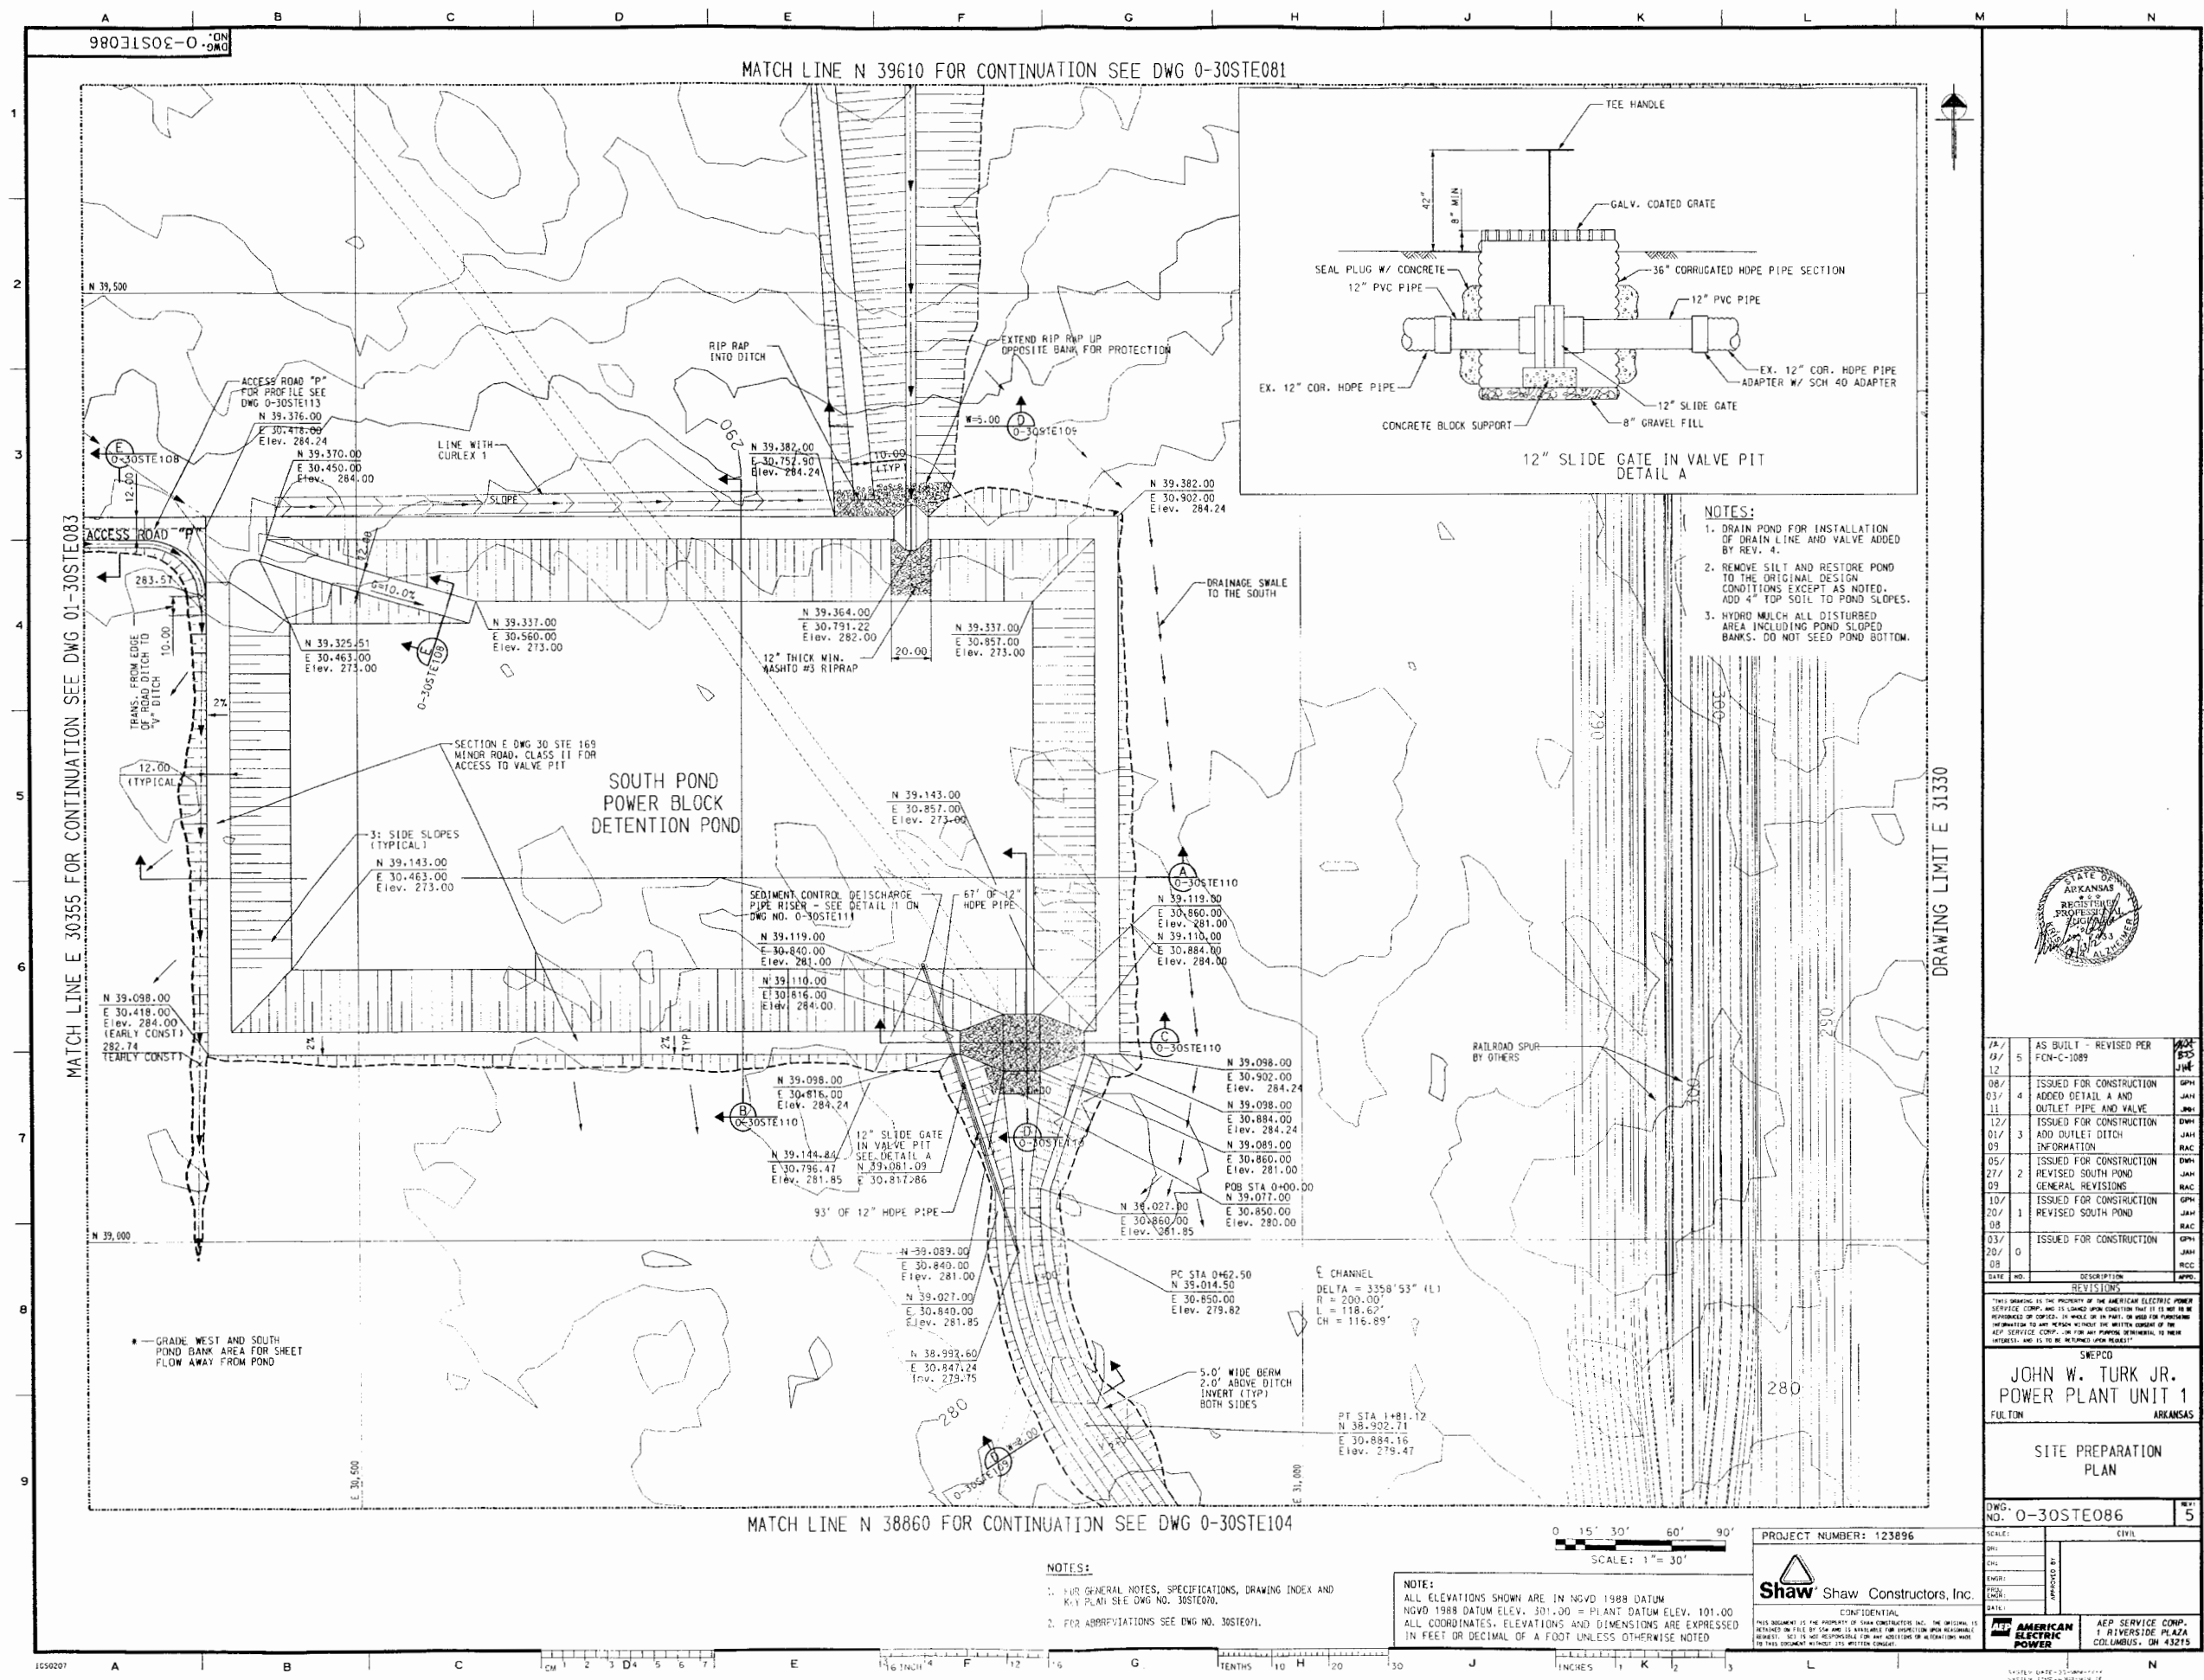

- NOTES:
- 1. DRAIN POND FOR INSTALLATION OF DRAIN LINE AND VALVE ADDED BY REV. 4.
 - 2. REMOVE SILT AND RESTORE POND TO THE ORIGINAL DESIGN. CONDITIONS EXCEPT AS NOTED. ADD 4" TOP SOIL TO POND SLOPES.
 - 3. HYDRO MULCH ALL DISTURBED AREA INCLUDING POND SLOPED BANKS. DO NOT SEED POND BOTTOM.



DATE	NO.	DESCRIPTION	APPROVED
7/1/12	5	AS BUILT - REVISED PER FCN-C-1089	JWT
08/03/11	4	ISSUED FOR CONSTRUCTION ADDED DETAIL A AND OUTLET PIPE AND VALVE	JWT
12/01/09	3	ISSUED FOR CONSTRUCTION ADD OUTLET DITCH INFORMATION	JWT
05/27/09	2	ISSUED FOR CONSTRUCTION REVISED SOUTH POND GENERAL REVISIONS	JWT
10/20/08	1	ISSUED FOR CONSTRUCTION REVISED SOUTH POND	JWT
03/20/08	0	ISSUED FOR CONSTRUCTION	JWT

THIS DRAWING IS THE PROPERTY OF THE AMERICAN ELECTRIC POWER SERVICE CORP. AND IS LOANED TO YOU UNDER THE CONDITION THAT IT IS NOT TO BE REPRODUCED OR COPIED, IN WHOLE OR IN PART, OR USED FOR ANY PURPOSES WITHOUT THE WRITTEN CONSENT OF THE AMERICAN ELECTRIC POWER SERVICE CORP. FOR ANY PURPOSES, IN WHOLE OR IN PART, OR TO BE REPRODUCED OR COPIED, IN WHOLE OR IN PART, OR TO BE USED FOR ANY PURPOSES WITHOUT THE WRITTEN CONSENT OF THE AMERICAN ELECTRIC POWER SERVICE CORP.

SWEPCO
JOHN W. TURK JR.
POWER PLANT UNIT 1
FULTON ARKANSAS

SITE PREPARATION
PLAN

DWG. NO. 0-30STE086
REV. 5

SCALE:	CIVIL
DWG.	
CHKD.	
ENGR.	
APP'D BY:	
DATE:	

PROJECT NUMBER: 123896

Shaw Shaw Constructors, Inc.

 
CONFIDENTIAL


THIS DOCUMENT IS THE PROPERTY OF SHAW SHAW CONSTRUCTORS, INC. THE ORIGINAL IS TO BE KEPT IN THE FILES OF SHAW SHAW CONSTRUCTORS, INC. AND IS NOT TO BE REPRODUCED OR COPIED, IN WHOLE OR IN PART, OR USED FOR ANY PURPOSES WITHOUT THE WRITTEN CONSENT OF SHAW SHAW CONSTRUCTORS, INC. FOR ANY PURPOSES, IN WHOLE OR IN PART, OR TO BE REPRODUCED OR COPIED, IN WHOLE OR IN PART, OR TO BE USED FOR ANY PURPOSES WITHOUT THE WRITTEN CONSENT OF SHAW SHAW CONSTRUCTORS, INC.

AMERICAN ELECTRIC POWER
AEP SERVICE CORP.
1 RIVERSIDE PLAZA
COLUMBUS, OH 43215

- NOTES:
- 1. FOR GENERAL NOTES, SPECIFICATIONS, DRAWING INDEX AND KEY PLAN SEE DWG NO. 30STE080.
 - 2. FOR ABBREVIATIONS SEE DWG NO. 30STE071.

NOTE:
ALL ELEVATIONS SHOWN ARE IN NGVD 1988 DATUM
NGVD 1988 DATUM ELEV. 301.00 = PLANT DATUM ELEV. 101.00
ALL COORDINATES, ELEVATIONS AND DIMENSIONS ARE EXPRESSED IN FEET OR DECIMAL OF A FOOT UNLESS OTHERWISE NOTED



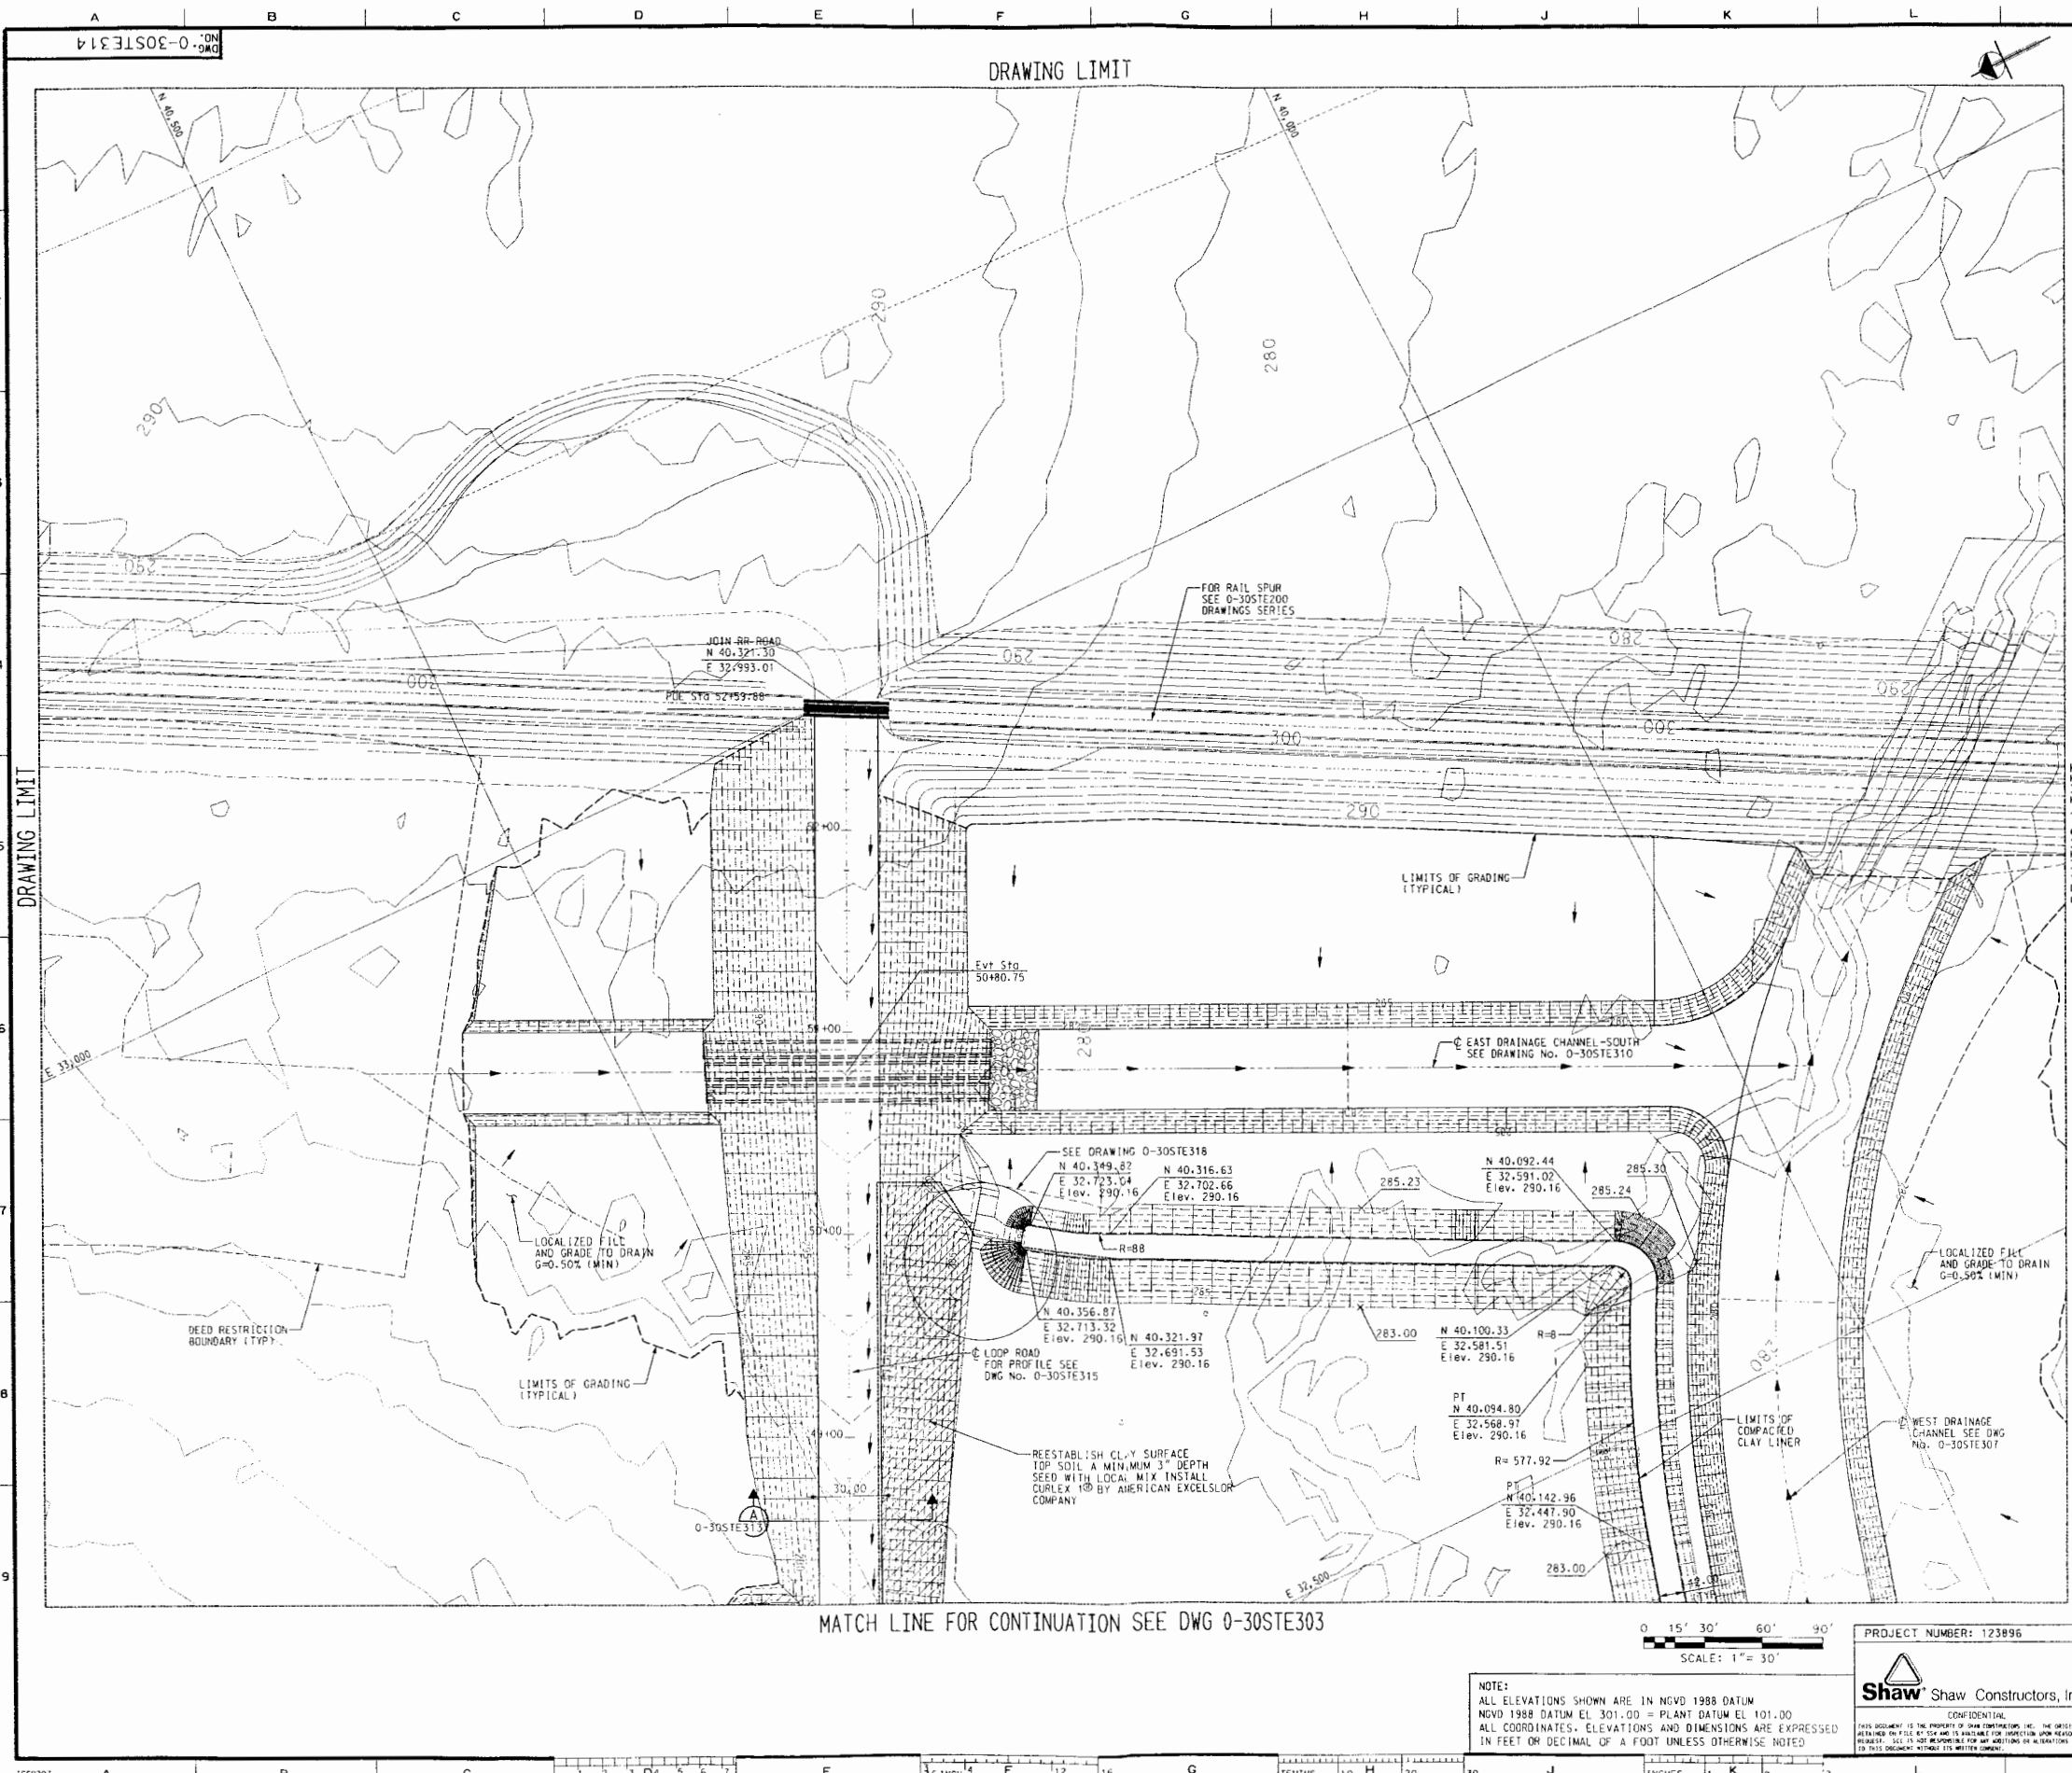

NOTES:
1. FOR GENERAL NOTES, LEGEND AND SPECIFICATIONS SEE DWG 0-30STE300.



DATE	NO.	DESCRIPTION	APPROVED
12/12	5	AS BUILT-REVISED PER FORN-C-956	BSS
03/08	4	ISSUED FOR CONSTRUCTION REVISED SOUTH AND EAST BERMS	JAH
05/10	3	ISSUED FOR CONSTRUCTION REVISED SECTION CALLOUT	JAH
03/10	2	ISSUED FOR CONSTRUCTION GENERAL REVISIONS	JAH
04/26	1	ISSUED FOR CONSTRUCTION GENERAL REVISIONS	JAH
05/09	0	ISSUED FOR CONSTRUCTION	JAH

REVISIONS

THIS DRAWING IS THE PROPERTY OF THE AMERICAN ELECTRIC POWER SERVICE CORP. AND IS LOANED TO YOU CONDITION THAT IT IS NOT TO BE REPRODUCED OR COPIED, IN WHOLE OR IN PART, OR USED FOR ANY OTHER PURPOSE WITHOUT THE WRITTEN CONSENT OF THE AEP SERVICE CORP. IN ANY MANNER DEVIATING FROM THE INTENT AND PURPOSE OF THE ORIGINAL DRAWING.

SHEET NO. 5

PROJECT NUMBER: 123896

JOHN W. TURK JR.
POWER PLANT UNIT 1
FULTON ARKANSAS

COAL HANDLING AREA
GRADING PLAN

CIVIL SITE PLANS

NOTE:
ALL ELEVATIONS SHOWN ARE IN NGVD 1988 DATUM
NGVD 1988 DATUM EL. 301.00 = PLANT DATUM EL. 101.00
ALL COORDINATES, ELEVATIONS AND DIMENSIONS ARE EXPRESSED IN FEET OR DECIMAL OF A FOOT UNLESS OTHERWISE NOTED


Shaw Constructors, Inc.

CONFIDENTIAL

THIS DOCUMENT IS THE PROPERTY OF SHAW CONSTRUCTORS, INC. THE ORIGINAL IS TO BE KEPT IN THE FILES OF THE PROJECT AND IS NOT TO BE LOANED, REPRODUCED, COPIED, OR USED FOR ANY OTHER PURPOSE WITHOUT THE WRITTEN CONSENT OF SHAW CONSTRUCTORS, INC. IN ANY MANNER DEVIATING FROM THE INTENT AND PURPOSE OF THE ORIGINAL DRAWING.

AMERICAN ELECTRIC POWER

AEP SERVICE CORP.
1 RIVERSIDE PLAZA
COLUMBUS, OH 43215

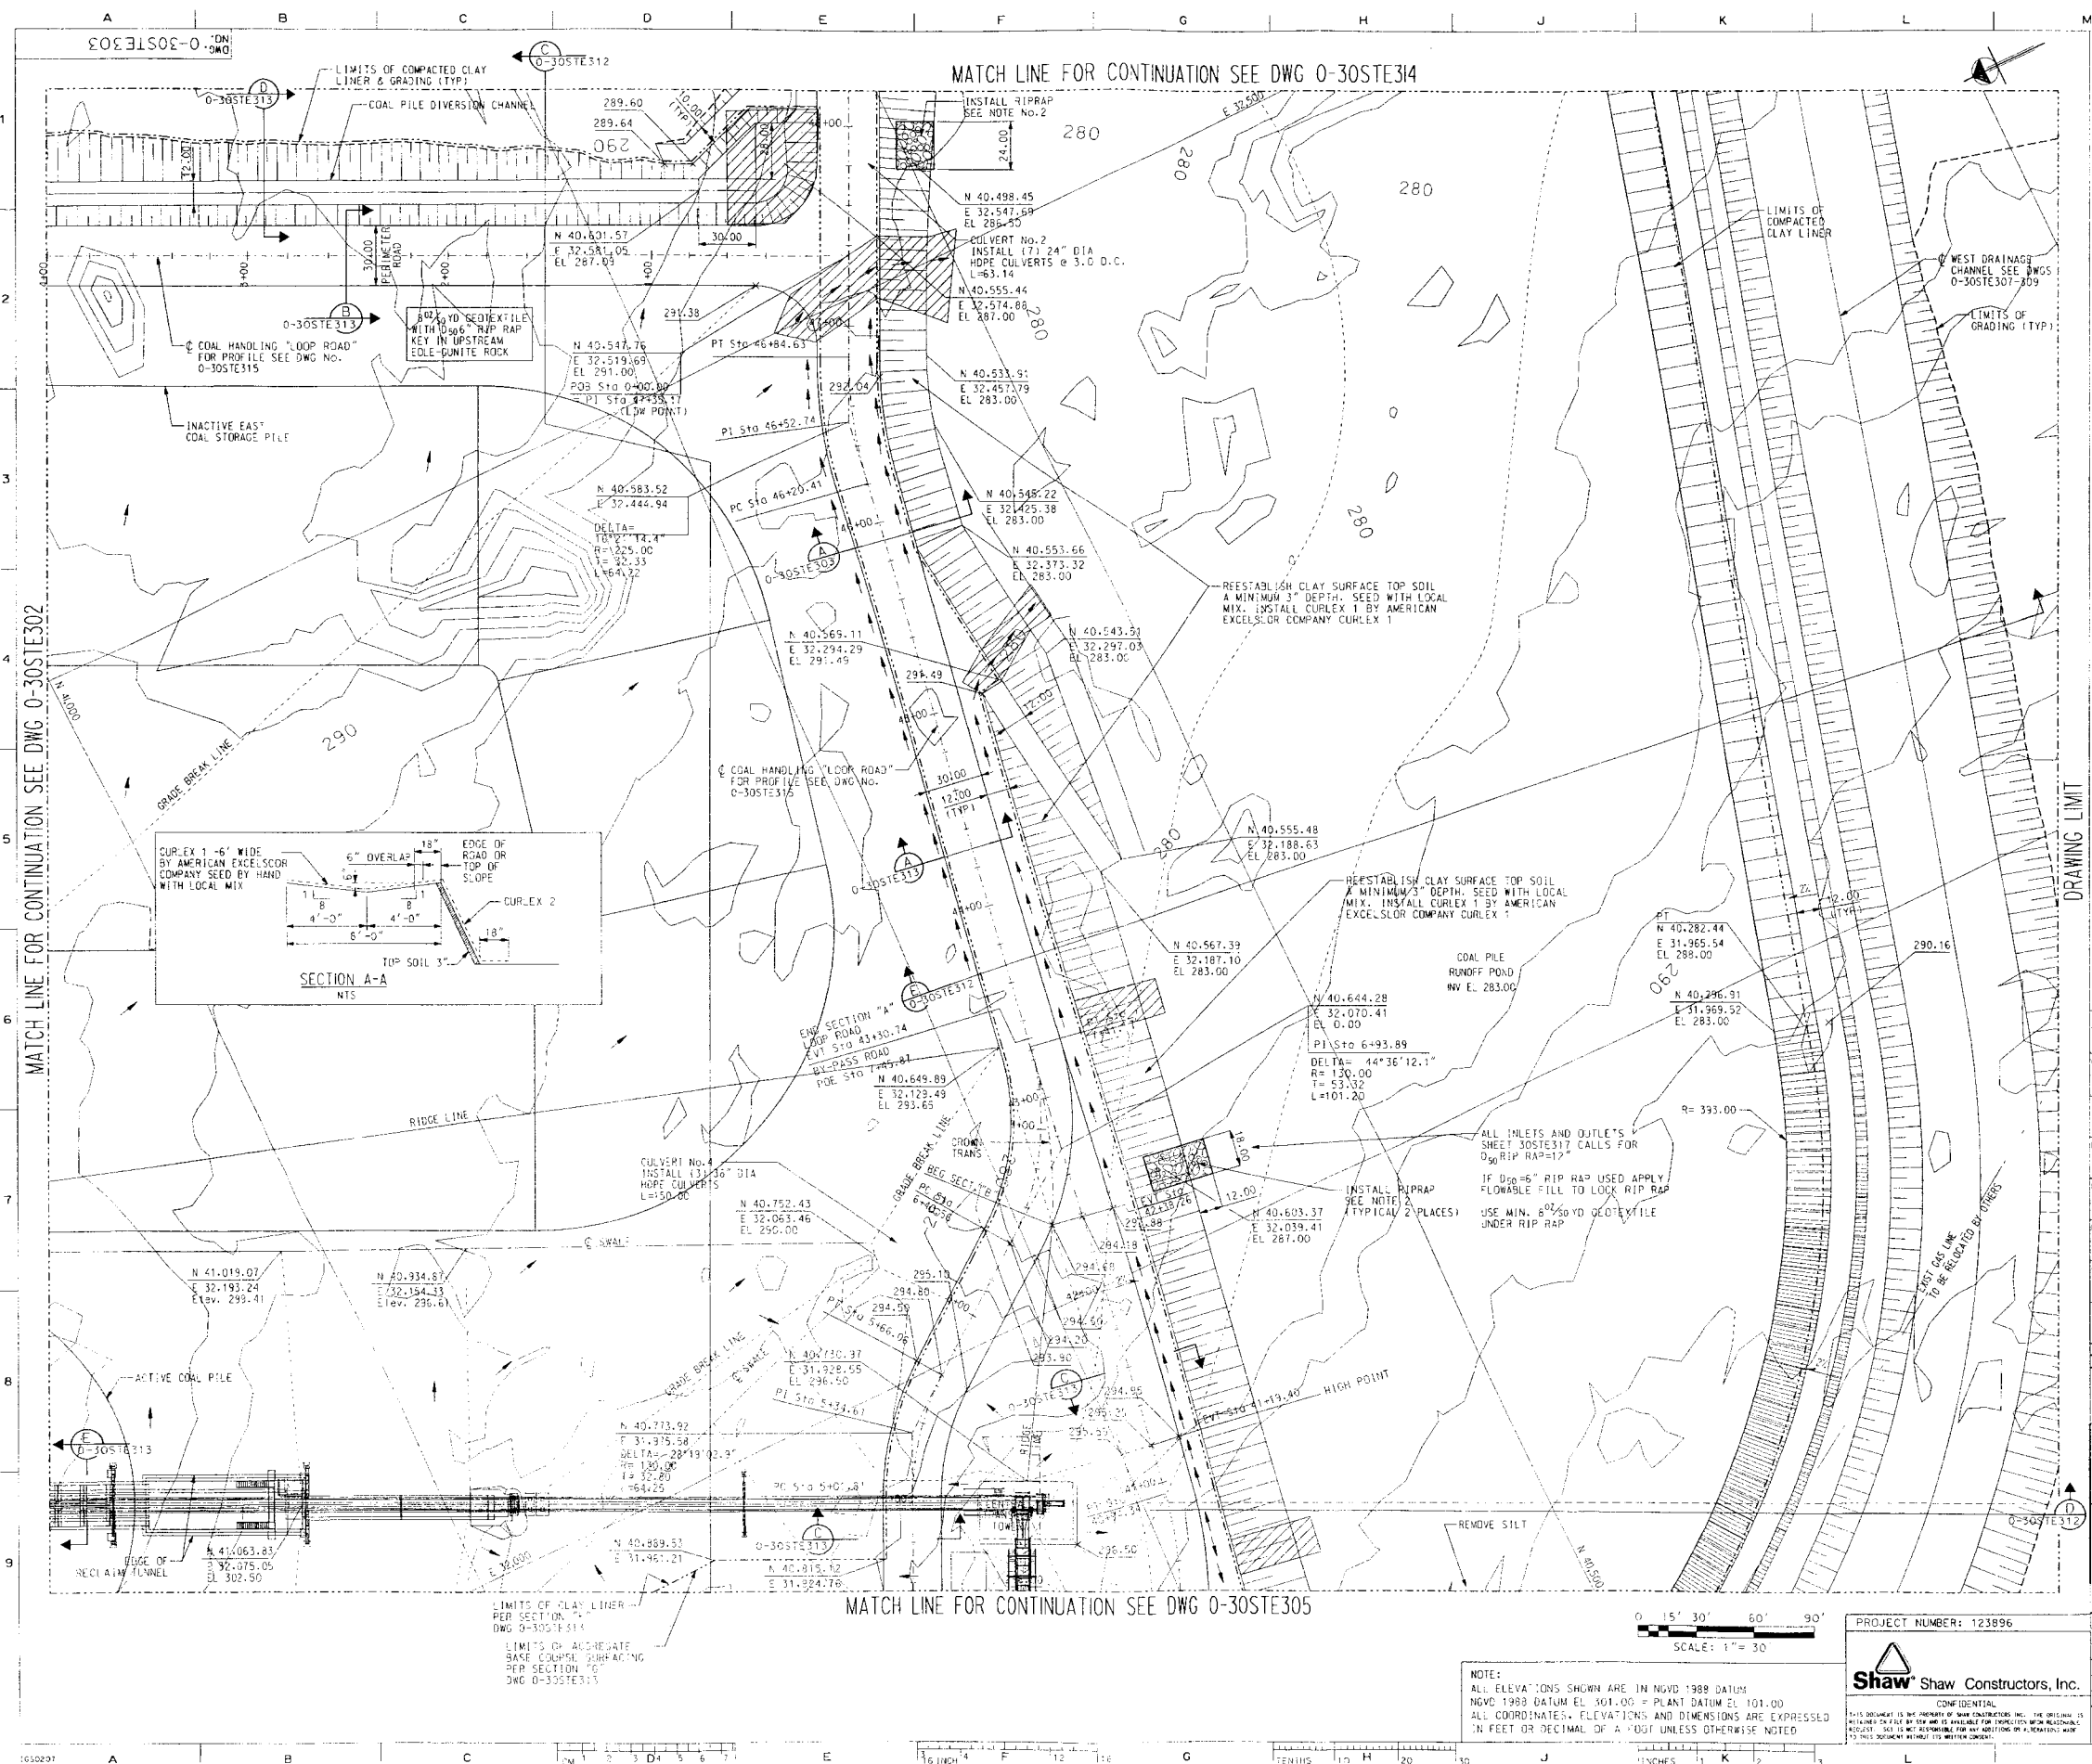

- NOTES:
1. FOR GENERAL NOTES, LEGEND AND SPECIFICATIONS SEE DWG O-30STE300.
 2. FOR RIP RAP AT HOPE CULVERT OUTLETS, SEE DETAIL 1 ON DRAWING NO. O-30STE317.



DATE	NO.	DESCRIPTION	APPROVED
12/15/07	7	AS BUILT - REVISED PER FON-C-688 AND FON-C-936	JWT
08/03/07	6	ISSUED FOR CONSTRUCTION REVISED SOUTH BERM	CPH
07/07/07	5	ISSUED FOR CONSTRUCTION REMOVED RAMP OVER TUNNEL	CPH
06/01/07	4	ISSUED FOR CONSTRUCTION ADDED RAMP OVER TUNNEL	CPH
03/22/07	3	ISSUED FOR CONSTRUCTION ADDED CULVERT INFORMATION	CPH
04/28/07	2	ISSUED FOR CONSTRUCTION GENERAL REVISION	DWH
05/05/07	1	ISSUED FOR CONSTRUCTION GENERAL REVISION	CPH
11/30/07	0	ISSUED FOR CONSTRUCTION	AGC

THIS DRAWING IS THE PROPERTY OF SHAW CONSTRUCTORS, INC. IT IS LOANED TO YOU FOR YOUR INFORMATION AND USE ONLY. IT IS NOT TO BE REPRODUCED OR COPIED IN ANY MANNER OR FOR ANY PURPOSE WITHOUT THE WRITTEN CONSENT OF SHAW CONSTRUCTORS, INC. ANY REPRODUCTION OR COPIING OF THIS DRAWING WITHOUT ITS WRITTEN CONSENT IS PROHIBITED.

PROJECT NUMBER: 123896

SCALE: 1" = 30'

DATE: 12/15/07

APPROVED BY: [Signature]

PROJECT: JOHN W. TURK JR. POWER PLANT UNIT 1

LOCATION: FULTON, ARKANSAS

COAL HANDLING AREA GRADING PLAN

CIVIL SITE PLANS

DWG. NO. O-30STE303

REV. 7

DATE: 12/15/07

BY: [Signature]

CHECKED BY: [Signature]

APPROVED BY: [Signature]

DATE: 12/15/07

PROJECT: JOHN W. TURK JR. POWER PLANT UNIT 1

LOCATION: FULTON, ARKANSAS

COAL HANDLING AREA GRADING PLAN

CIVIL SITE PLANS

DWG. NO. O-30STE303

REV. 7

DATE: 12/15/07

BY: [Signature]


CHECKED BY: [Signature]

APPROVED BY: [Signature]

DATE: 12/15/07

NOTE:

ALL ELEVATIONS SHOWN ARE IN NGVD 1988 DATUM
MVD 1988 DATUM EL. 101.00 = PLANT DATUM EL. 101.00
ALL COORDINATES, ELEVATIONS AND DIMENSIONS ARE EXPRESSED IN FEET OR DECIMAL OF A FOOT UNLESS OTHERWISE NOTED

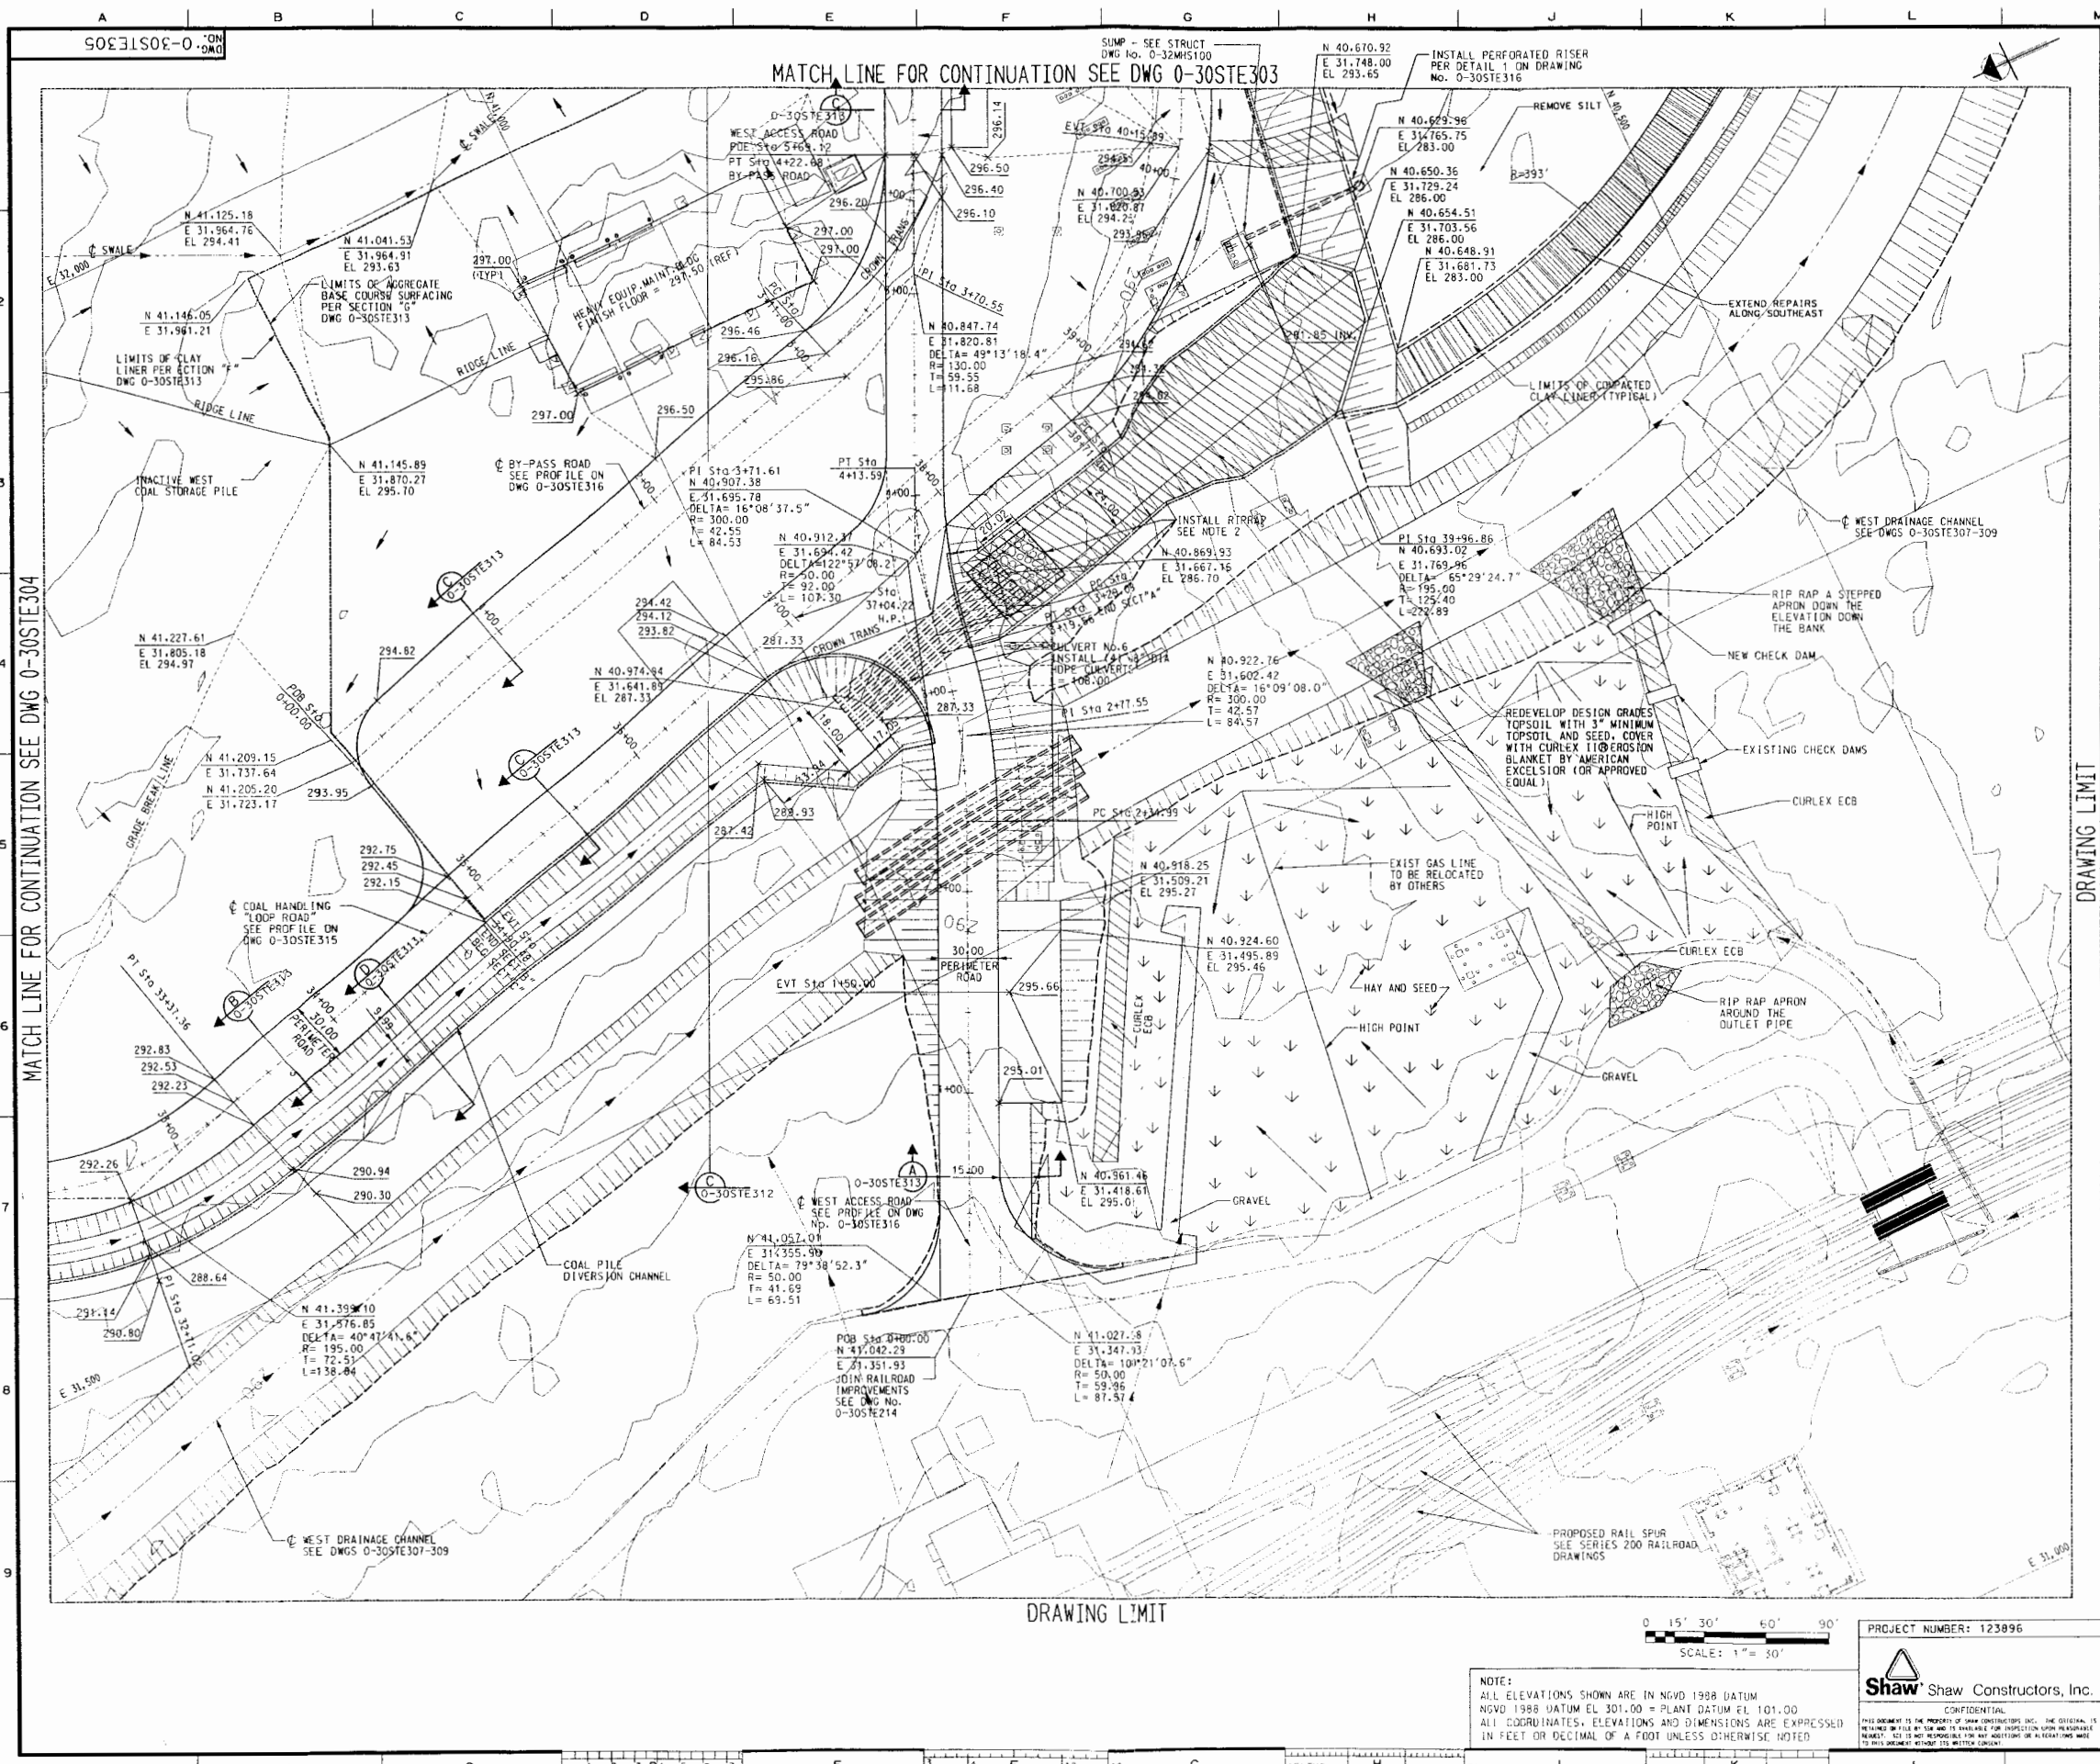

NOTES:
1. FOR GENERAL NOTES, LEGEND AND SPECIFICATIONS SEE DWG 0-30STE300.
2. FOR RIP RAP AT HOPE CULVERT OUTLETS, SEE DETAIL 1 ON DRAWING NO. 0-30STE317.



DATE	DESCRIPTION	APPROVED
12/13/12	AS BUILT - REVISED PER FCN C-996 AND FCN C-1221	JWT
04/30/12	ISSUED FOR CONSTRUCTION ADDED EROSION MEASURES	JWT
09/01/11	ISSUED FOR CONSTRUCTION REMOVED RAMP OVER TRENCH	JWT
09/01/10	ISSUED FOR CONSTRUCTION ADDED RAMP OVER TRENCH	JWT
03/02/10	ISSUED FOR CONSTRUCTION REVISED RISER LOCATION	JWT
12/23/09	ISSUED FOR CONSTRUCTION ADDED RISER AND SUMP	JWT
04/28/09	ISSUED FOR CONSTRUCTION GENERAL REVISION	JWT
05/05/08	ISSUED FOR CONSTRUCTION GENERAL REVISION	JWT
11/30/07	ISSUED FOR CONSTRUCTION	JWT


THIS DRAWING IS THE PROPERTY OF THE AMERICAN ELECTRIC POWER SERVICE CORP. AND IS LOANED TO YOU FOR YOUR INFORMATION ONLY. IT IS NOT TO BE REPRODUCED OR COPIED IN WHOLE OR IN PART, OR USED FOR ANY OTHER PURPOSE WITHOUT THE WRITTEN CONSENT OF THE AEP SERVICE CORP. FOR ANY PURPOSE OR REUSE OF THIS DRAWING, YOU MUST OBTAIN THE WRITTEN CONSENT OF THE AEP SERVICE CORP. AND IS TO BE RETURNED TO THE AEP SERVICE CORP. IMMEDIATELY UPON REQUEST.

SWP
JOHN W. TURK JR.
POWER PLANT UNIT 1
FULTON ARKANSAS
COAL HANDLING AREA
GRADING PLAN
CIVIL SITE PLANS
DWG NO. 0-30STE305
REV 8

NOTE:
ALL ELEVATIONS SHOWN ARE IN NGVD 1988 DATUM
NGVD 1988 DATUM EL 301.00 = PLANT DATUM EL 101.00
ALL COORDINATES, ELEVATIONS AND DIMENSIONS ARE EXPRESSED IN FEET OR DECIMAL OF A FOOT UNLESS OTHERWISE NOTED

PROJECT NUMBER: 123096
Shaw Constructors, Inc.
CONFIDENTIAL
THIS DOCUMENT IS THE PROPERTY OF SHAW CONSTRUCTORS, INC. THE ORIGINAL IS TO BE KEPT IN FILE BY THE AEP SERVICE CORP. FOR INSPECTION AND RECORDS. IT IS NOT TO BE REPRODUCED OR COPIED IN WHOLE OR IN PART, OR USED FOR ANY OTHER PURPOSE WITHOUT THE WRITTEN CONSENT OF THE AEP SERVICE CORP. AND IS TO BE RETURNED TO THE AEP SERVICE CORP. IMMEDIATELY UPON REQUEST.

AMERICAN ELECTRIC POWER
AEP SERVICE CORP.
1 RIVERSIDE PLAZA
COLEMANVILLE, OH 43015

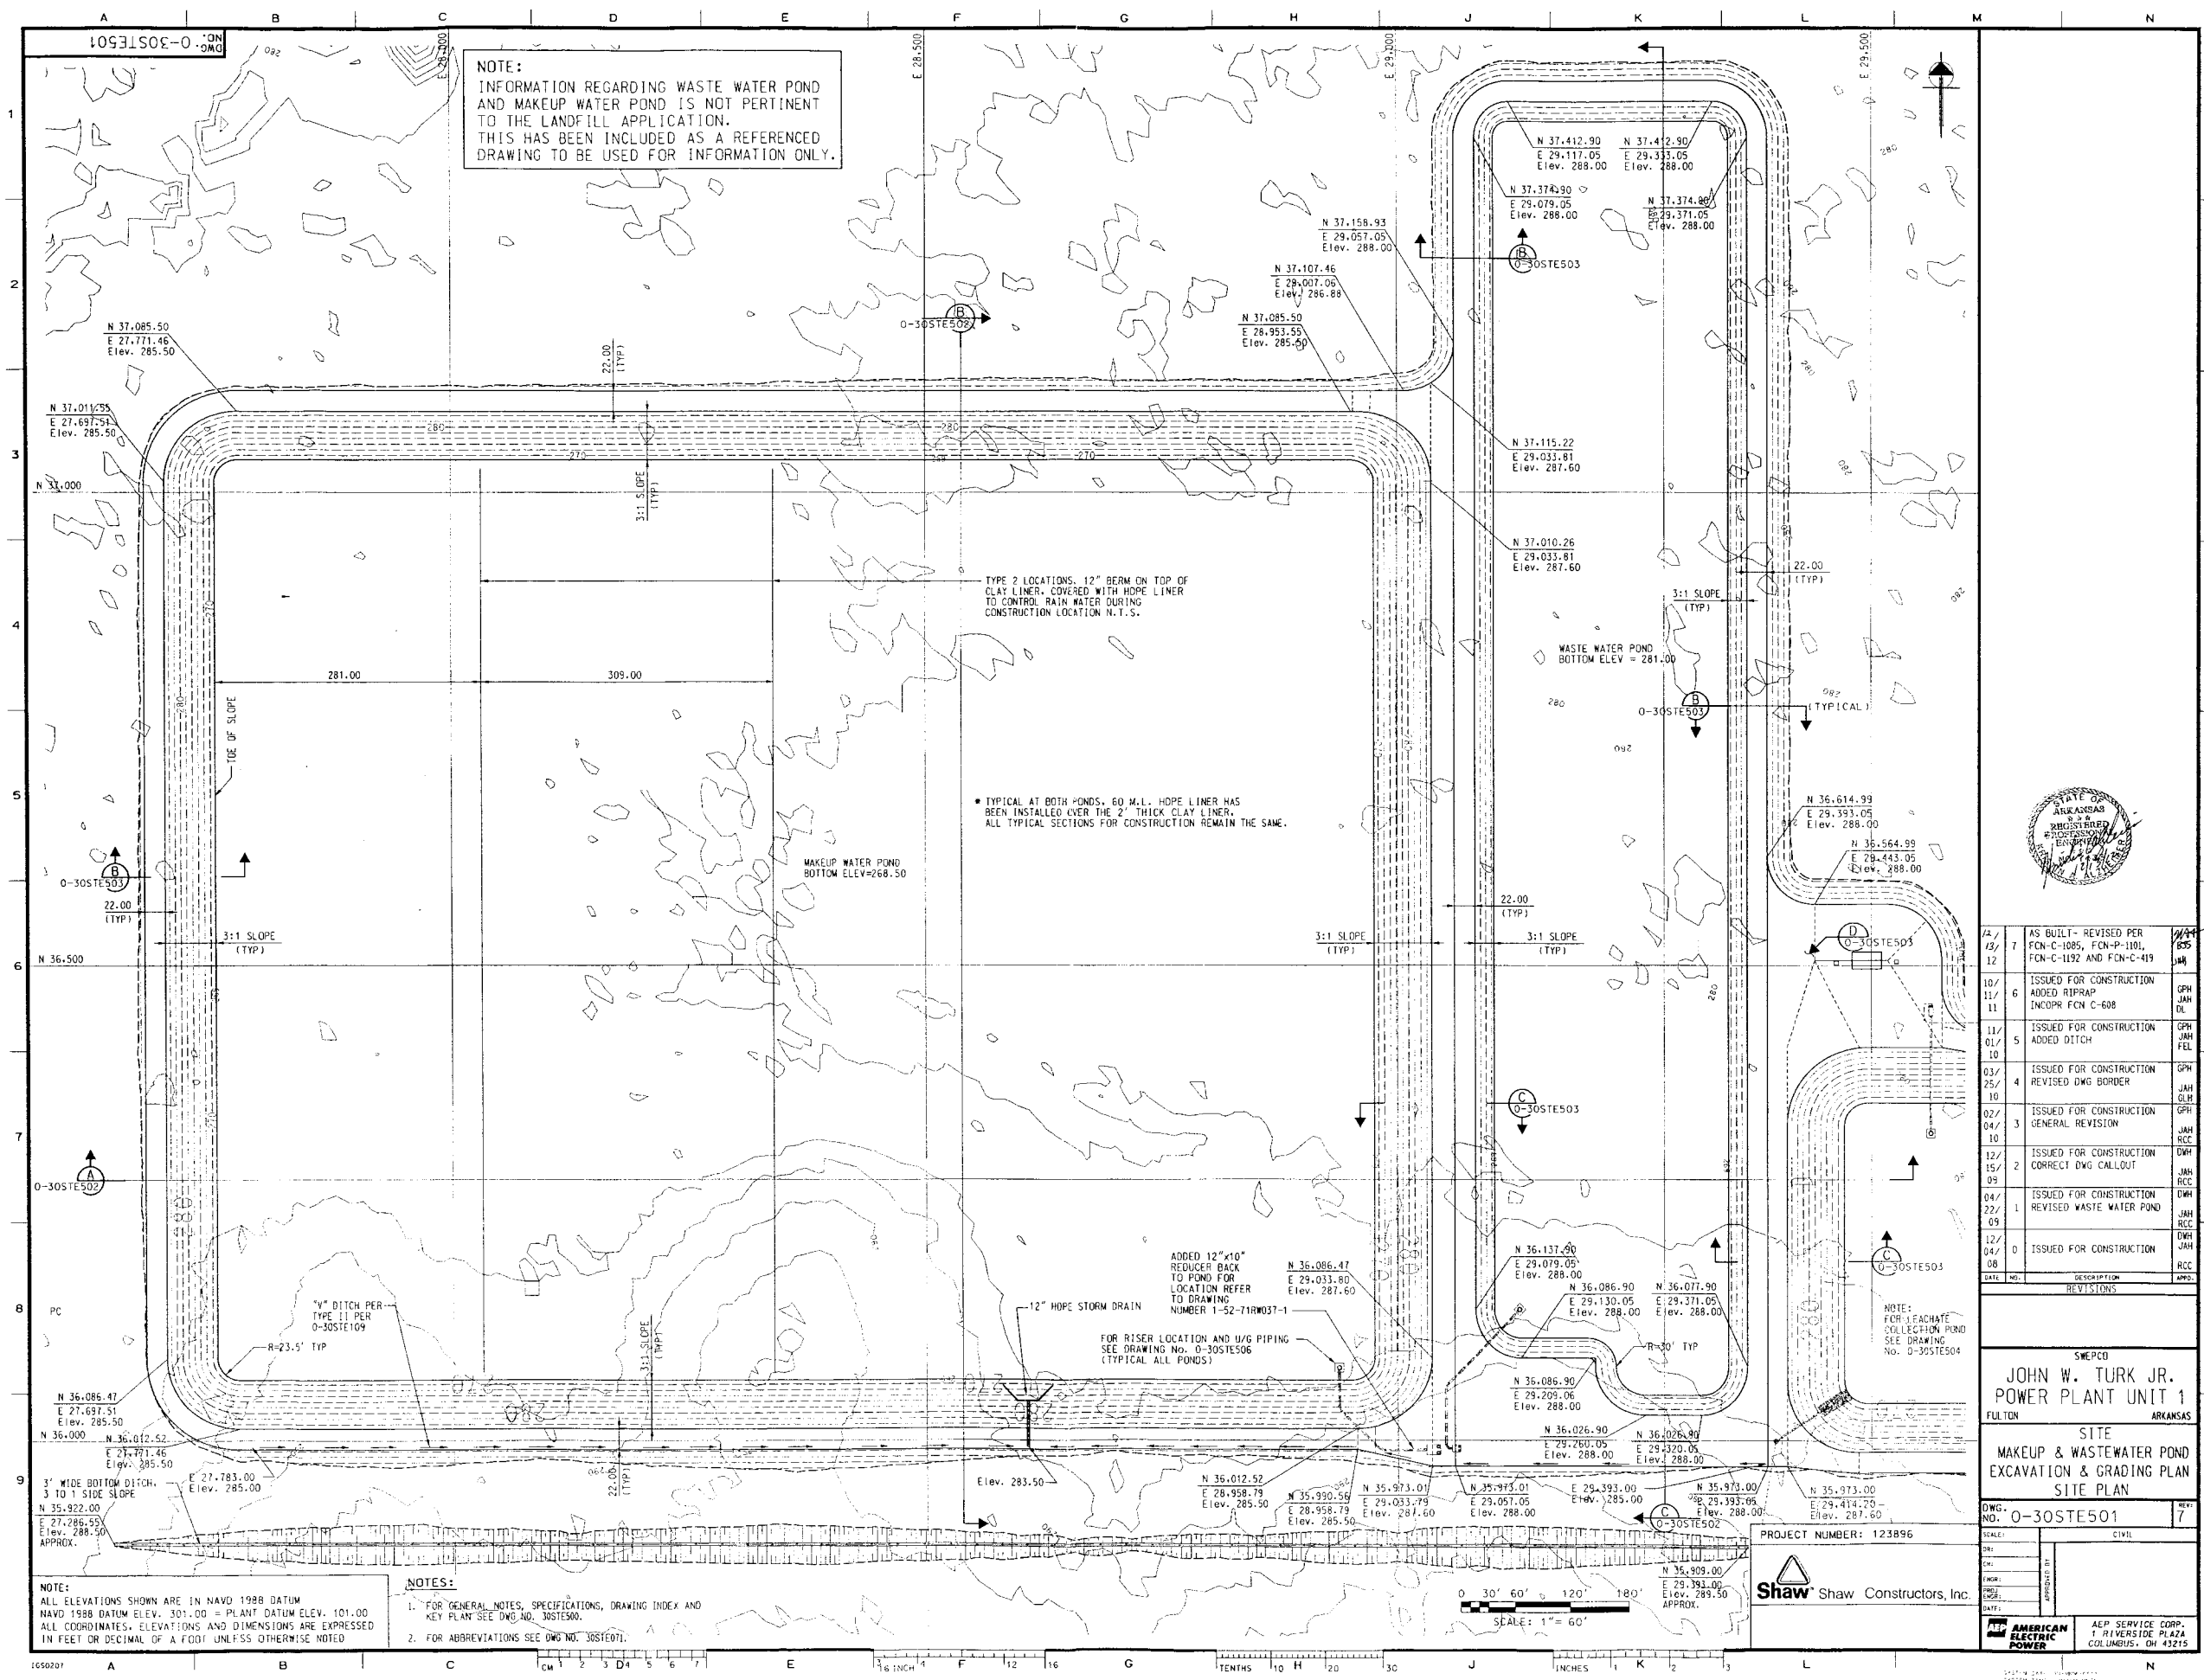

NOTE:
INFORMATION REGARDING WASTE WATER POND
AND MAKEUP WATER POND IS NOT PERTINENT
TO THE LANDFILL APPLICATION.
THIS HAS BEEN INCLUDED AS A REFERENCED
DRAWING TO BE USED FOR INFORMATION ONLY.

TYPE 2 LOCATIONS. 12" BERM ON TOP OF
CLAY LINER, COVERED WITH HOPE LINER
TO CONTROL RAIN WATER DURING
CONSTRUCTION LOCATION N.T.S.

* TYPICAL AT BOTH PONDS. 60 M.L. HOPE LINER HAS
BEEN INSTALLED OVER THE 2' THICK CLAY LINER.
ALL TYPICAL SECTIONS FOR CONSTRUCTION REMAIN THE SAME.

MAKEUP WATER POND
BOTTOM ELEV=268.50

WASTE WATER POND
BOTTOM ELEV = 281.00

NOTE:
FOR EACH DATE
COLLECTION POND
SEE DRAWING
NO. 0-30STE504

NOTE:
ALL ELEVATIONS SHOWN ARE IN NAVD 1988 DATUM
NAVD 1988 DATUM ELEV. 501.00 = PLANT DATUM ELEV. 101.00
ALL COORDINATES, ELEVATIONS AND DIMENSIONS ARE EXPRESSED
IN FEET OR DECIMAL OF A FOOT UNLESS OTHERWISE NOTED

NOTES:
1. FOR GENERAL NOTES, SPECIFICATIONS, DRAWING INDEX AND
KEY PLAN SEE DWG NO. 0-30STE500.
2. FOR ABBREVIATIONS SEE DWG NO. 0-30STE01.



DATE	NO.	DESCRIPTION	APP.
12/08	0	ISSUED FOR CONSTRUCTION	JWH
04/09	1	ISSUED FOR CONSTRUCTION REVISED WASTE WATER POND	JWH
12/09	2	ISSUED FOR CONSTRUCTION CORRECT DWG CALLOUT	JWH
02/10	3	ISSUED FOR CONSTRUCTION GENERAL REVISION	JWH
03/10	4	ISSUED FOR CONSTRUCTION REVISED DWG BORDER	JWH
11/10	5	ISSUED FOR CONSTRUCTION ADDED DITCH	JWH
10/11	6	ISSUED FOR CONSTRUCTION ADDED RIPRAP INCORP FCN C-608	JWH
12/12	7	AS BUILT - REVISED PER FCN C-1085, FCN P-1101, FCN C-1192 AND FCN C-419	JWH

SWPCO
JOHN W. TURK JR.
POWER PLANT UNIT 1
FULTON ARKANSAS

SITE
MAKEUP & WASTEWATER POND
EXCAVATION & GRADING PLAN
SITE PLAN

DWG. NO. 0-30STE501

PROJECT NUMBER: 123896

Shaw Shaw Constructors, Inc.




DATE: 12/08

SCALE: 1" = 60'

APP. JWH

REV. 7

FOR SERVICE CORP.
1 RIVERSIDE PLAZA
COLUMBUS, OH 43215

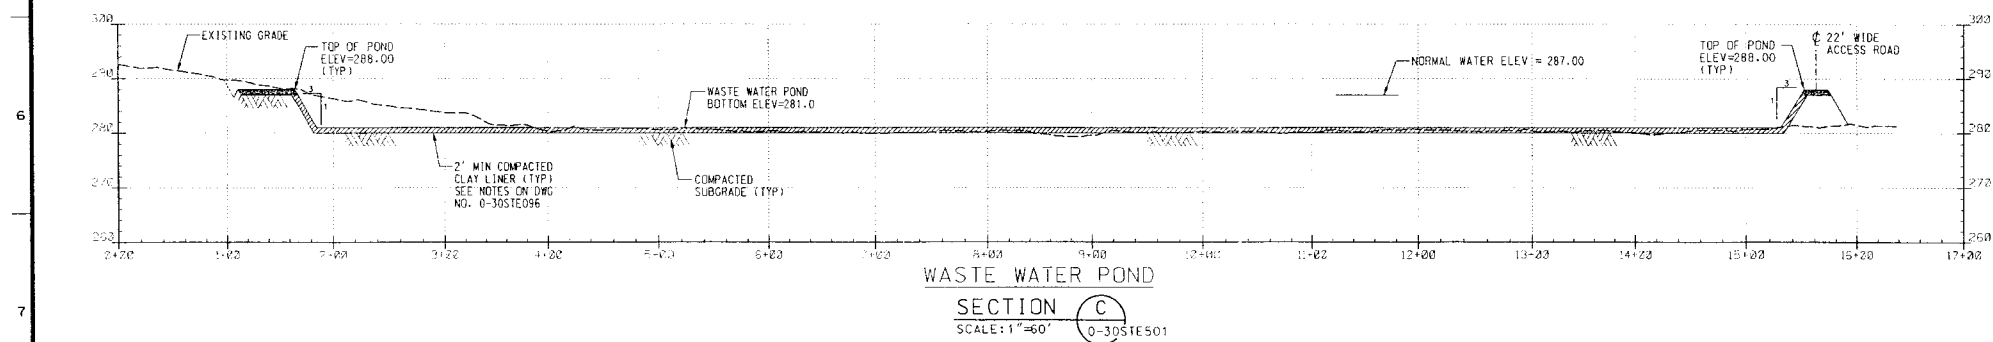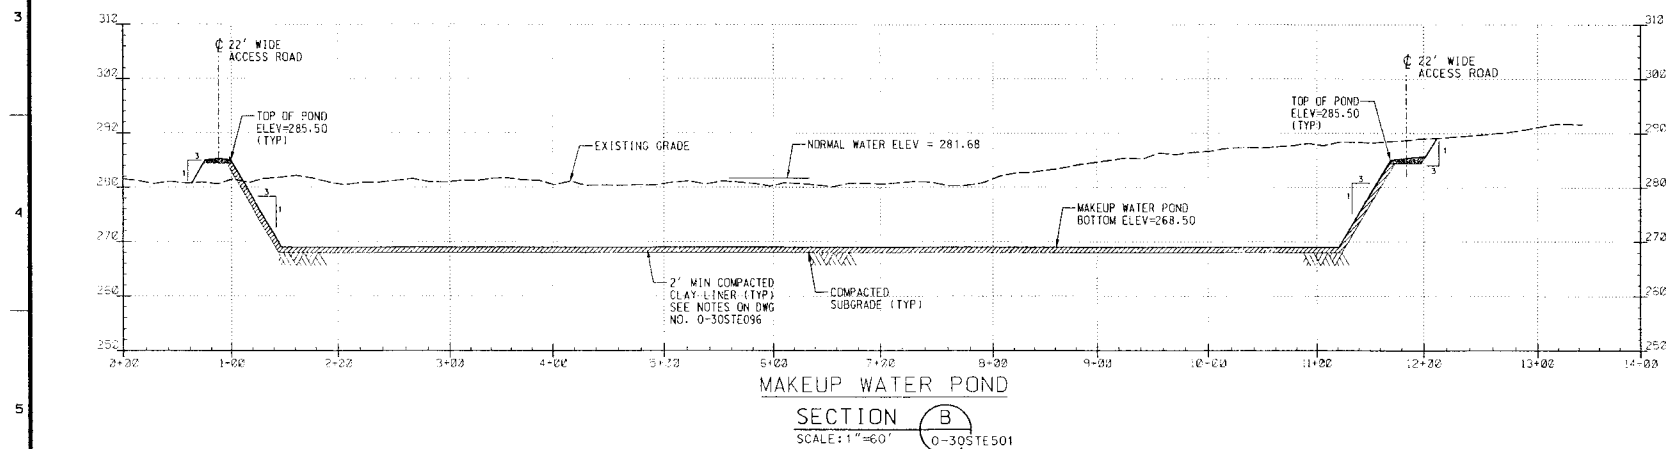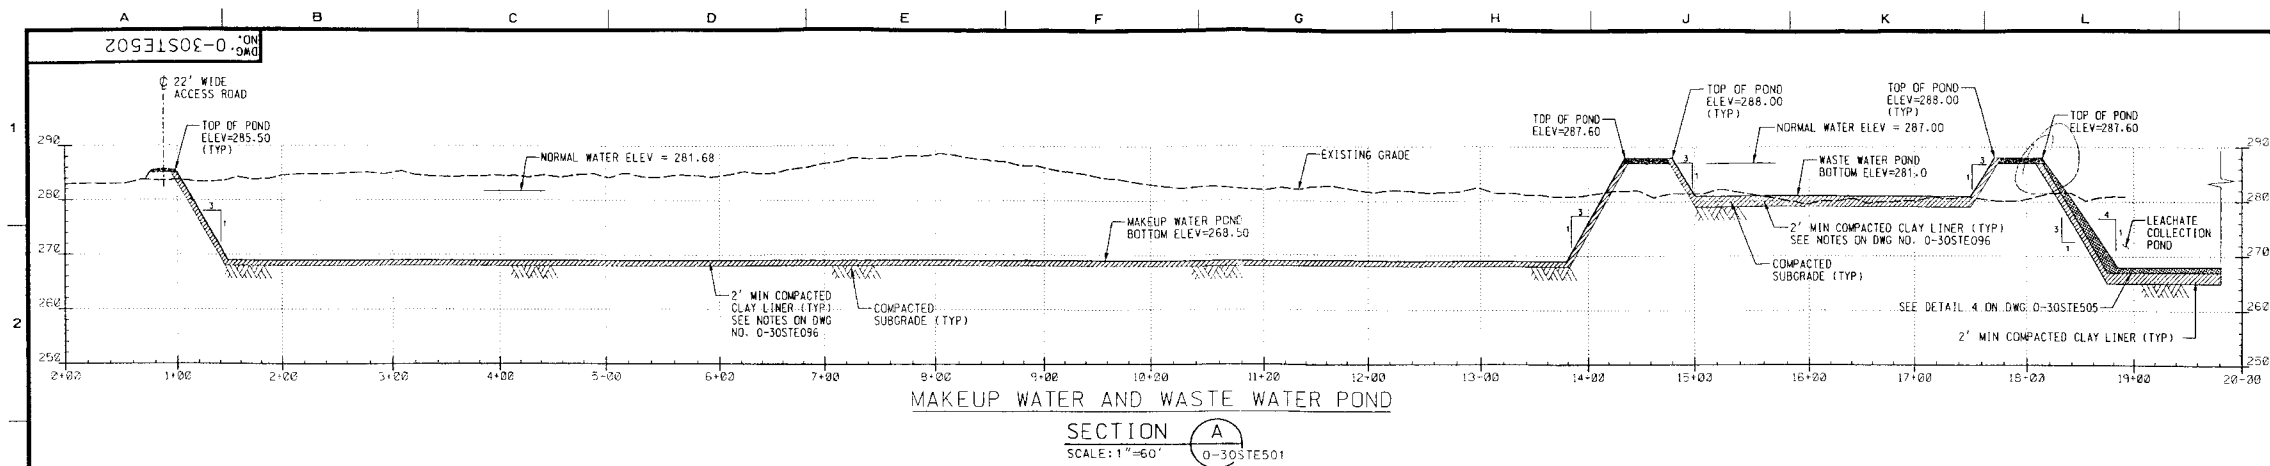


NOTE:
INFORMATION REGARDING WASTE WATER POND
AND MAKEUP WATER POND IS NOT PERTINENT
TO THE LANDFILL APPLICATION.
THIS HAS BEEN INCLUDED AS A REFERENCED
DRAWING TO BE USED FOR INFORMATION ONLY.

NOTES:

- FOR GENERAL NOTES, SPECIFICATIONS, DRAWING INDEX AND KEY PLAN SEE DWG NO. 30STE500.
- FOR ABBREVIATIONS SEE DWG NO. 30STE071.

 NOTE:
ALL ELEVATIONS SHOWN ARE IN NAVD 1988 DATUM
NAVD 1988 DATUM ELEV. 301.00 = PLANT DATUM ELEV. 101.00
ALL COORDINATES, ELEVATIONS AND DIMENSIONS ARE EXPRESSED
IN FEET OR DECIMAL OF A FOOT UNLESS OTHERWISE NOTED






PROJECT NUMBER: 123896
Shaw Shaw Constructors, Inc.



12/12	8	AS BUILT- REVISED PER DCN-C-1004 AND FCN-C-1005	JAH
12/29/10	7	ISSUED FOR PERMIT ADDED HDPE LINER AT LEACHATE POND	GPH JAH MCM
10/04/10	6	ISSUED FOR CONSTRUCTION REVISED LINER NOTE	GPH JAH MCM
09/02/10	5	ISSUED FOR CONSTRUCTION ADDED CLAY LINER TO MAKEUP WATER POND	GPH JAH FEL
03/25/10	4	ISSUED FOR CONSTRUCTION REVISED DWG BORDER REMOVED CLAY LINER	GPH JAH GLH
02/04/10	3	ISSUED FOR CONSTRUCTION GENERAL REVISION	GPH JAH RCC
04/22/09	2	ISSUED FOR CONSTRUCTION REVISED WASTE WATER POND	DWH JAH RCC
02/23/09	1	ISSUED FOR CONSTRUCTION ADD NOTES 4 AND 5	DWH JAH RCC
12/04/08	0	ISSUED FOR CONSTRUCTION	DWH JAH RAC

SWEPCO
JOHN W. TURK JR.
POWER PLANT UNIT 1
FULTON ARKANSAS
SITE
MAKEUP & WASTEWATER POND
SECTIONS & NOTES
SITE PLAN


DWG. NO. 0-30STE502
REV. 8
SCALE: CIVIL
DATE: 12/12/12
APPROVED BY: [Signature]
PROJECT: [Blank]
DRAWN BY: [Blank]
CHECKED BY: [Blank]
DATE: [Blank]
AMERICAN ELECTRIC POWER
AEP SERVICE CORP.
1 RIVERSIDE PLAZA
COLUMBUS, OH 43215

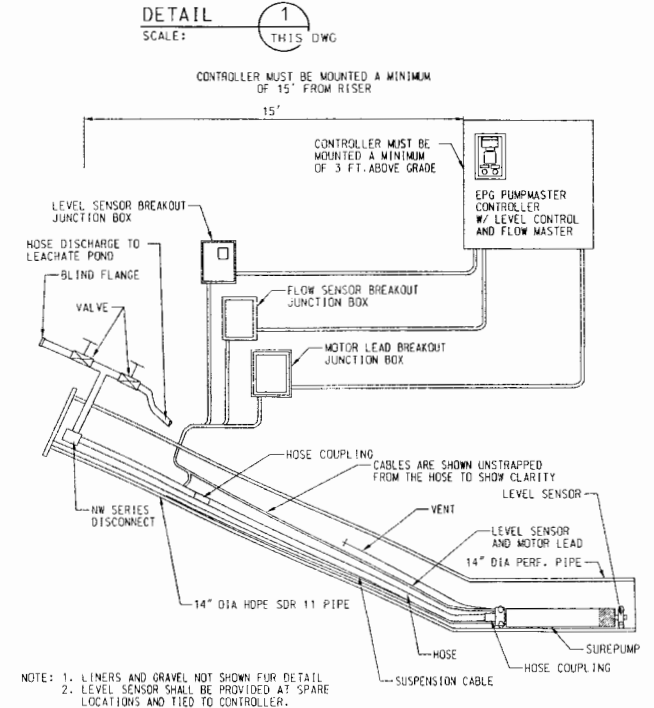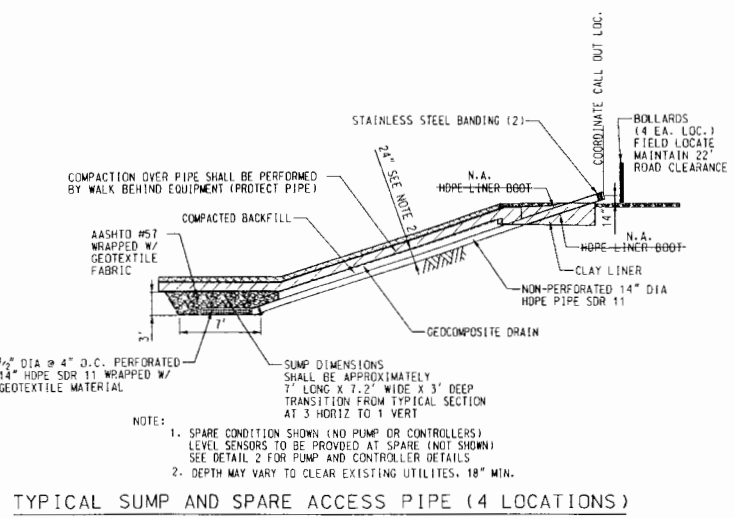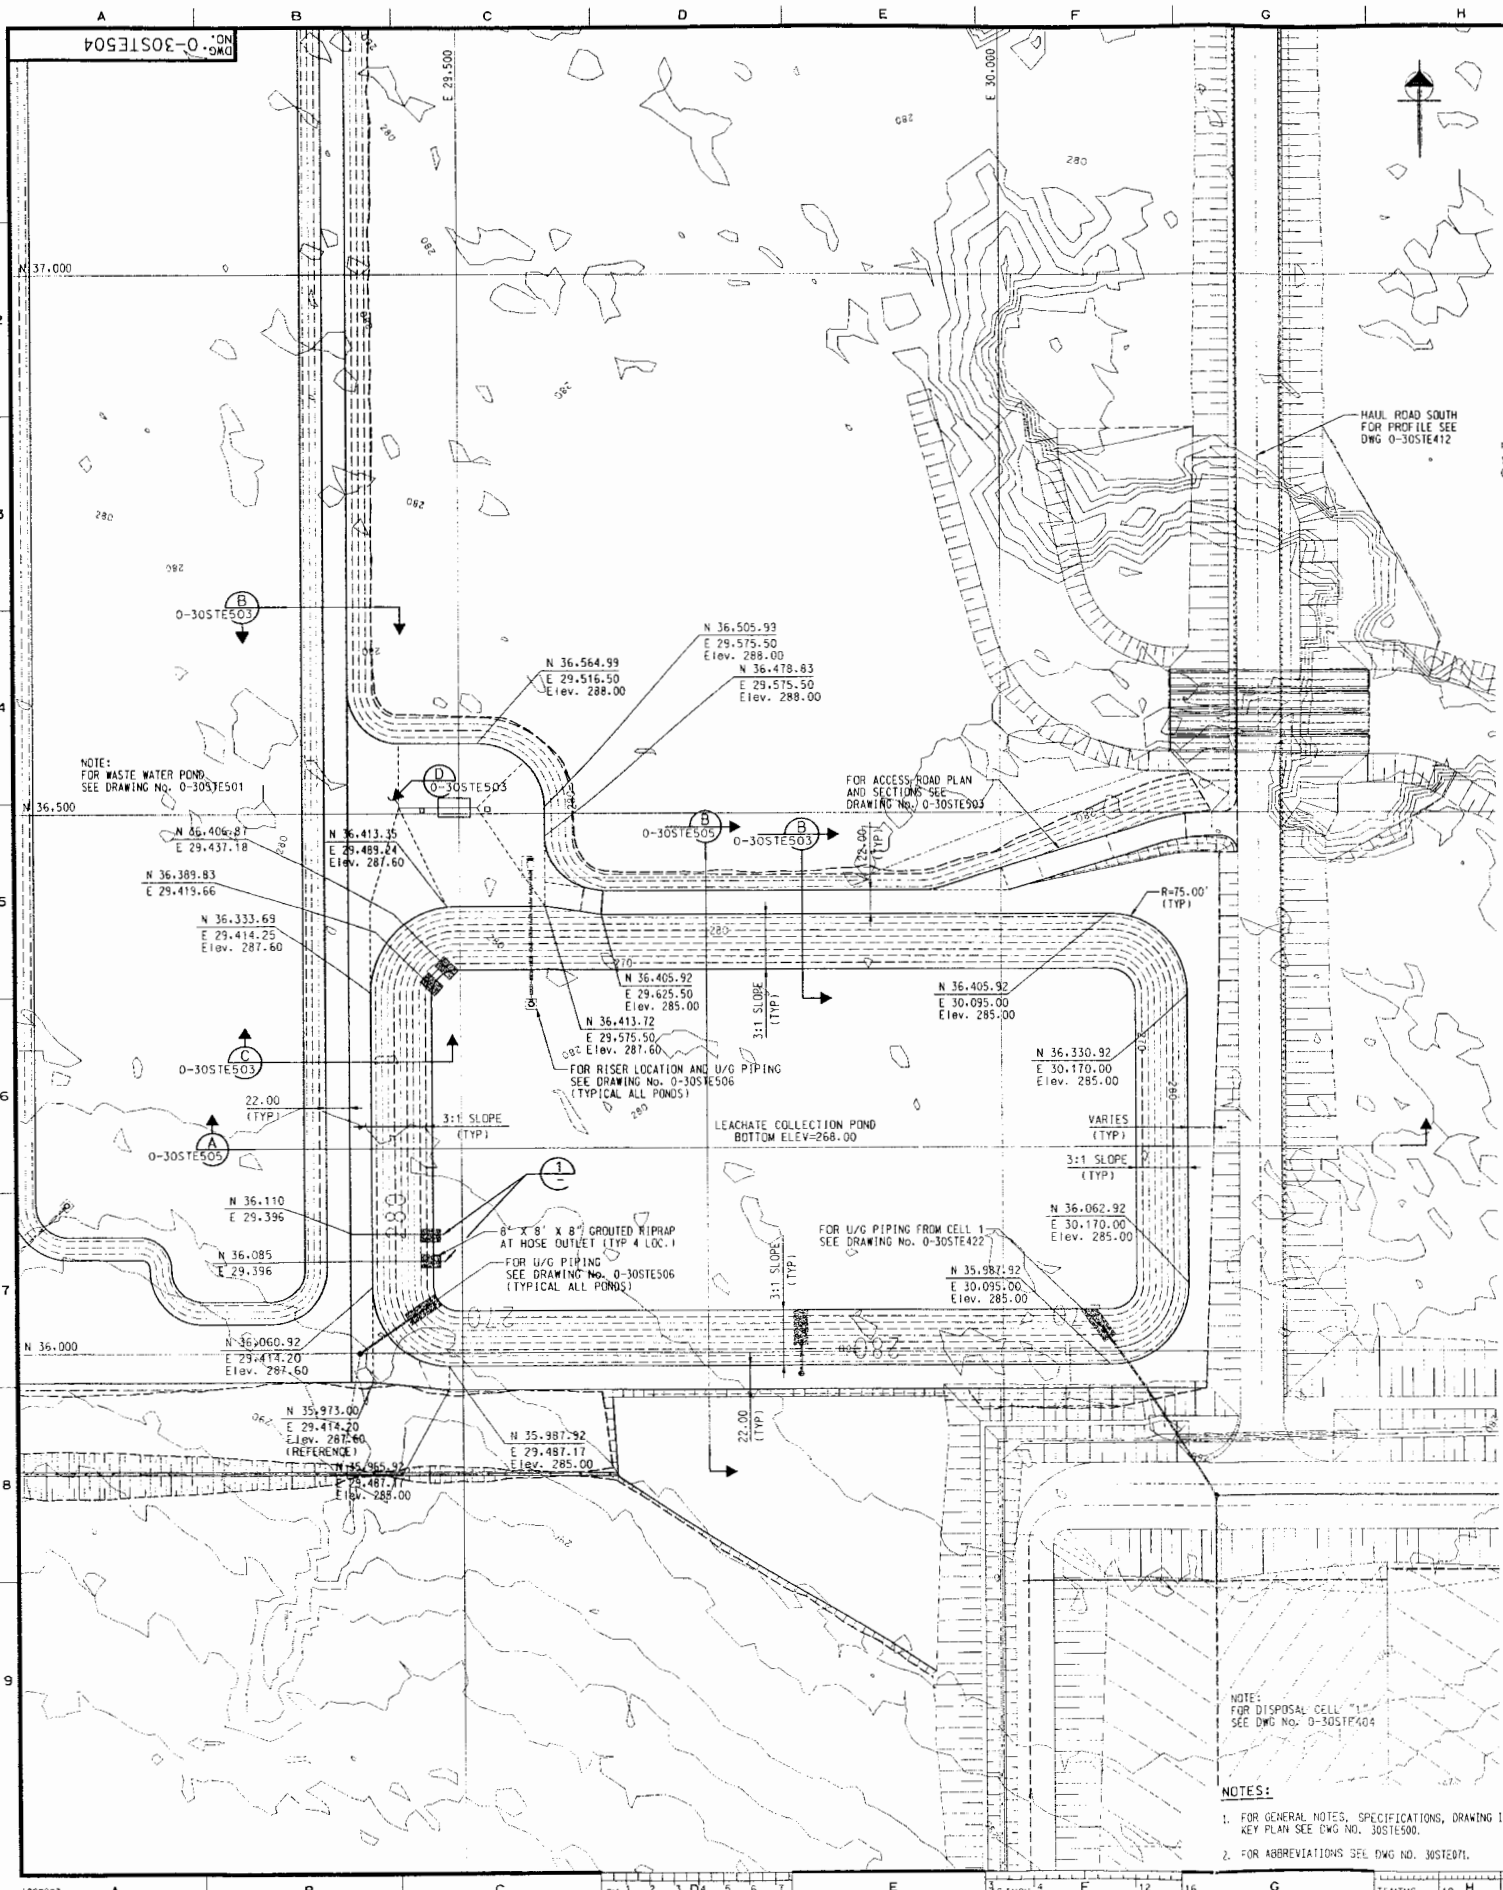

SUMP WITH PUMP DETAIL (2 LOCATIONS)
DETAIL 2
SCALE: 1" = 60'

NOTE:
INFORMATION REGARDING WASTE WATER POND AND MAKEUP WATER POND IS NOT PERTINENT TO THE LANDFILL APPLICATION. THIS HAS BEEN INCLUDED AS A REFERENCED DRAWING TO BE USED FOR INFORMATION ONLY.

 NOTE:
ALL ELEVATIONS SHOWN ARE IN NAVD 1988 DATUM
NAVD 1988 DATUM ELEV. 301.00 = PLANT DATUM ELEV. 101.00
ALL COORDINATES, ELEVATIONS AND DIMENSIONS ARE EXPRESSED IN FEET OR DECIMAL OF A FOOT UNLESS OTHERWISE NOTED



PROJECT NUMBER: 123896
Shaw Shaw Constructors, Inc.




DATE	NO.	DESCRIPTION	APPROVED
12/14/12	7	AS-BUILT REVISION TO GRAPHICS PER FON-C-861	KAA
06/26/12	6	AS-BUILT FON-C-861	KLG
08/25/11	5	ISSUED FOR CONSTRUCTION ADDED SUMPS AND GEOCOMPOSITE DRAIN	JHH
03/25/10	4	ISSUED FOR CONSTRUCTION REVISED DWG BORDER	JHH
02/04/10	3	ISSUED FOR CONSTRUCTION GENERAL REVISION	GLH
12/15/09	2	ISSUED FOR CONSTRUCTION CORRECT DWG CALL OUT	JAH
04/22/09	1	ISSUED FOR CONSTRUCTION REVISED WASTE WATER POND	DWH
12/04/08	0	ISSUED FOR CONSTRUCTION	JAH

SNEPCO
JOHN W. TURK JR.
POWER PLANT UNIT 1
FULTON ARKANSAS

SITE
LEACHATE COLLECTION POND
EXCAVATION & GRADING PLAN
SITE PLAN

DWG. NO. 0-30STE504
SCALE: 1" = 60'
DATE: 12/14/12
PROJECT: 123896
SHEET: 7
APPROVED BY: [Signature]
CHECKED BY: [Signature]
DRAWN BY: [Signature]
DATE: 12/14/12
AEP SERVICE CORP.
1 RIVERSIDE PLAZA
COLUMBUS, OH 43215

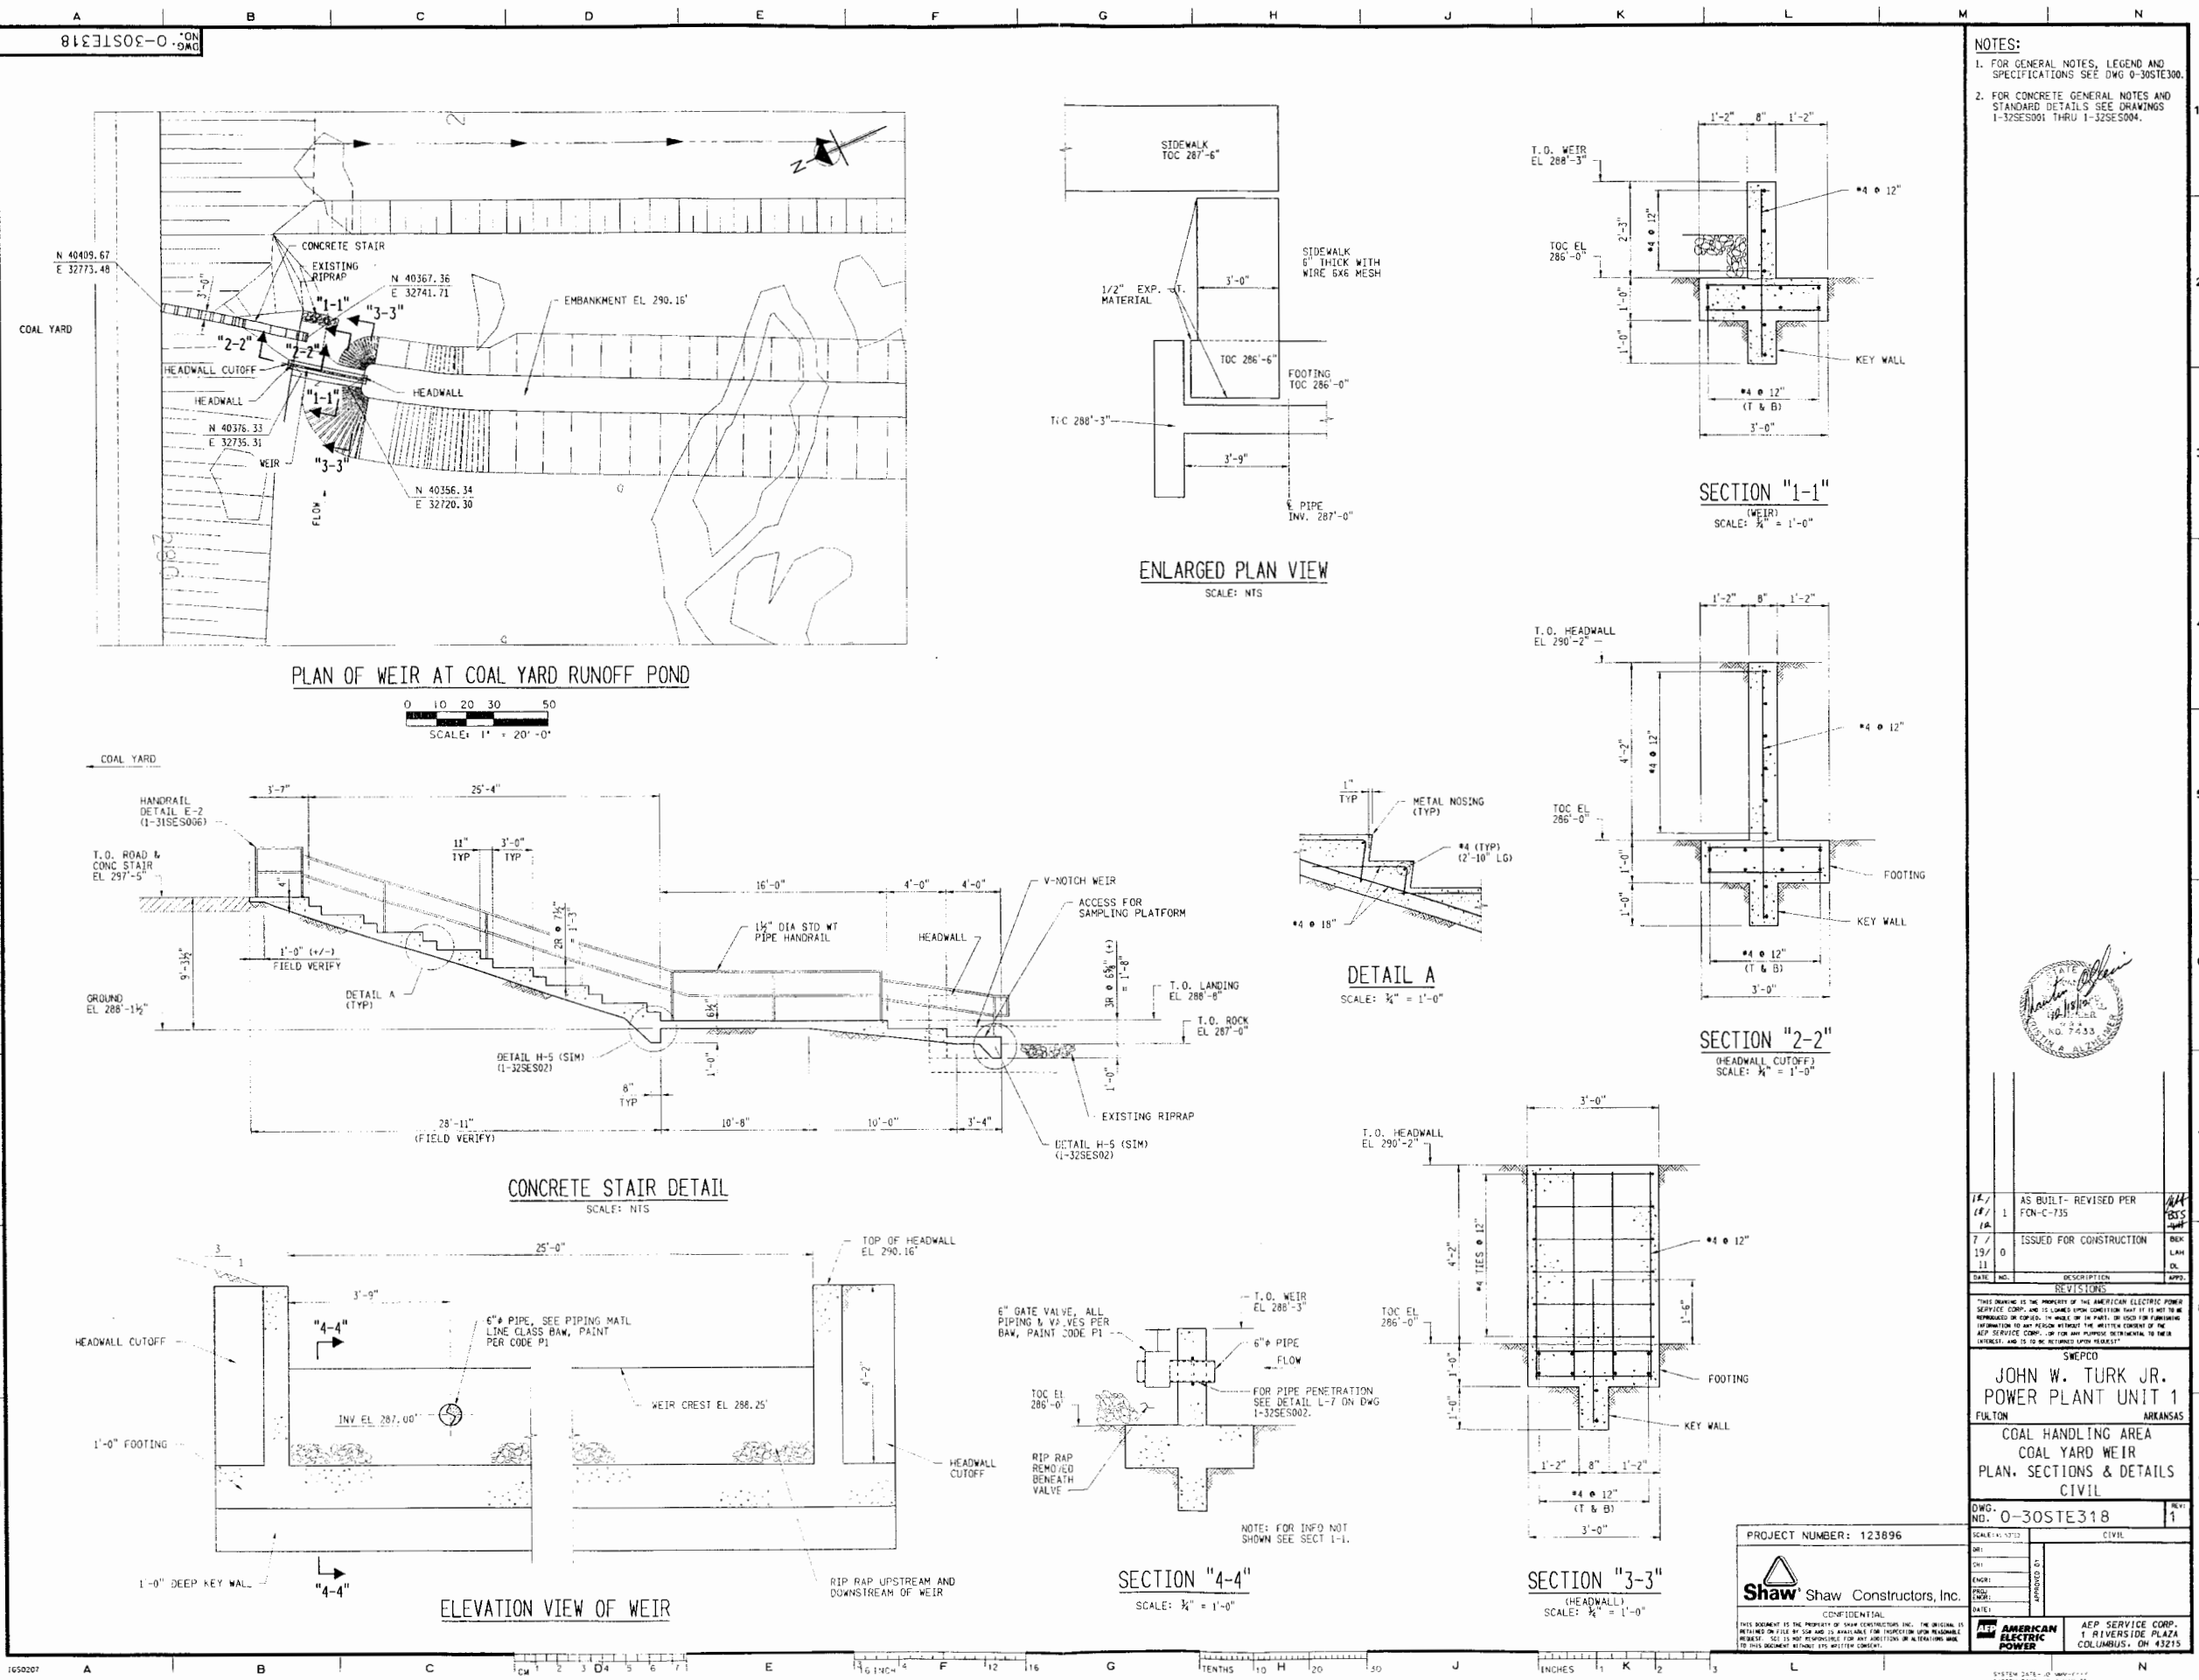

NOTES:
1. FOR GENERAL NOTES, LEGEND AND SPECIFICATIONS SEE DWG 0-30STE300.
2. FOR CONCRETE GENERAL NOTES AND STANDARD DETAILS SEE DRAWINGS 1-32SES001 THRU 1-32SES004.



1	AS BUILT- REVISED PER FORN-C-735	1/1
7	ISSUED FOR CONSTRUCTION	1/1
19		1/1
11		1/1


THIS DRAWING IS THE PROPERTY OF THE AMERICAN ELECTRIC POWER SERVICE CORP. AND IS LOANED TO YOU ON THE CONDITION THAT IT IS NOT TO BE REPRODUCED OR COPIED IN WHOLE OR IN PART, OR USED FOR THE FURNISHING OF INFORMATION TO ANY PERSON WITHOUT THE WRITTEN CONSENT OF THE AEP SERVICE CORP. FOR THE AMERICAN ELECTRIC POWER SERVICE CORP. AND IS TO BE RETURNED UPON REQUEST.



SWEPCO
JOHN W. TURK JR.
POWER PLANT UNIT 1
FULTON ARKANSAS
COAL HANDLING AREA
COAL YARD WEIR
PLAN, SECTIONS & DETAILS
CIVIL

DWG. NO. 0-30STE318	1
PROJECT NUMBER: 123896	CIVIL
DATE: 1/1/73	SCALE: 1/4" = 1'-0"
DESIGNED BY: [Signature]	CHECKED BY: [Signature]
ENGINEER: [Signature]	APPROVED BY: [Signature]
DATE: 1/1/73	DATE: 1/1/73


Shaw Constructors, Inc.
THIS DOCUMENT IS THE PROPERTY OF SHAW CONSTRUCTORS, INC. THE ORIGINAL IS RETAINED ON FILE BY SHAW AND IS AVAILABLE FOR INSPECTION UPON REQUEST. NO PART OF THIS DOCUMENT IS TO BE REPRODUCED OR COPIED IN WHOLE OR IN PART, OR USED FOR THE FURNISHING OF INFORMATION TO ANY PERSON WITHOUT THE WRITTEN CONSENT OF SHAW CONSTRUCTORS, INC. AND IS TO BE RETURNED UPON REQUEST.

AMERICAN ELECTRIC POWER
AEP SERVICE CORP.
1 RIVERSIDE PLAZA
COLUMBUS, OH 43215

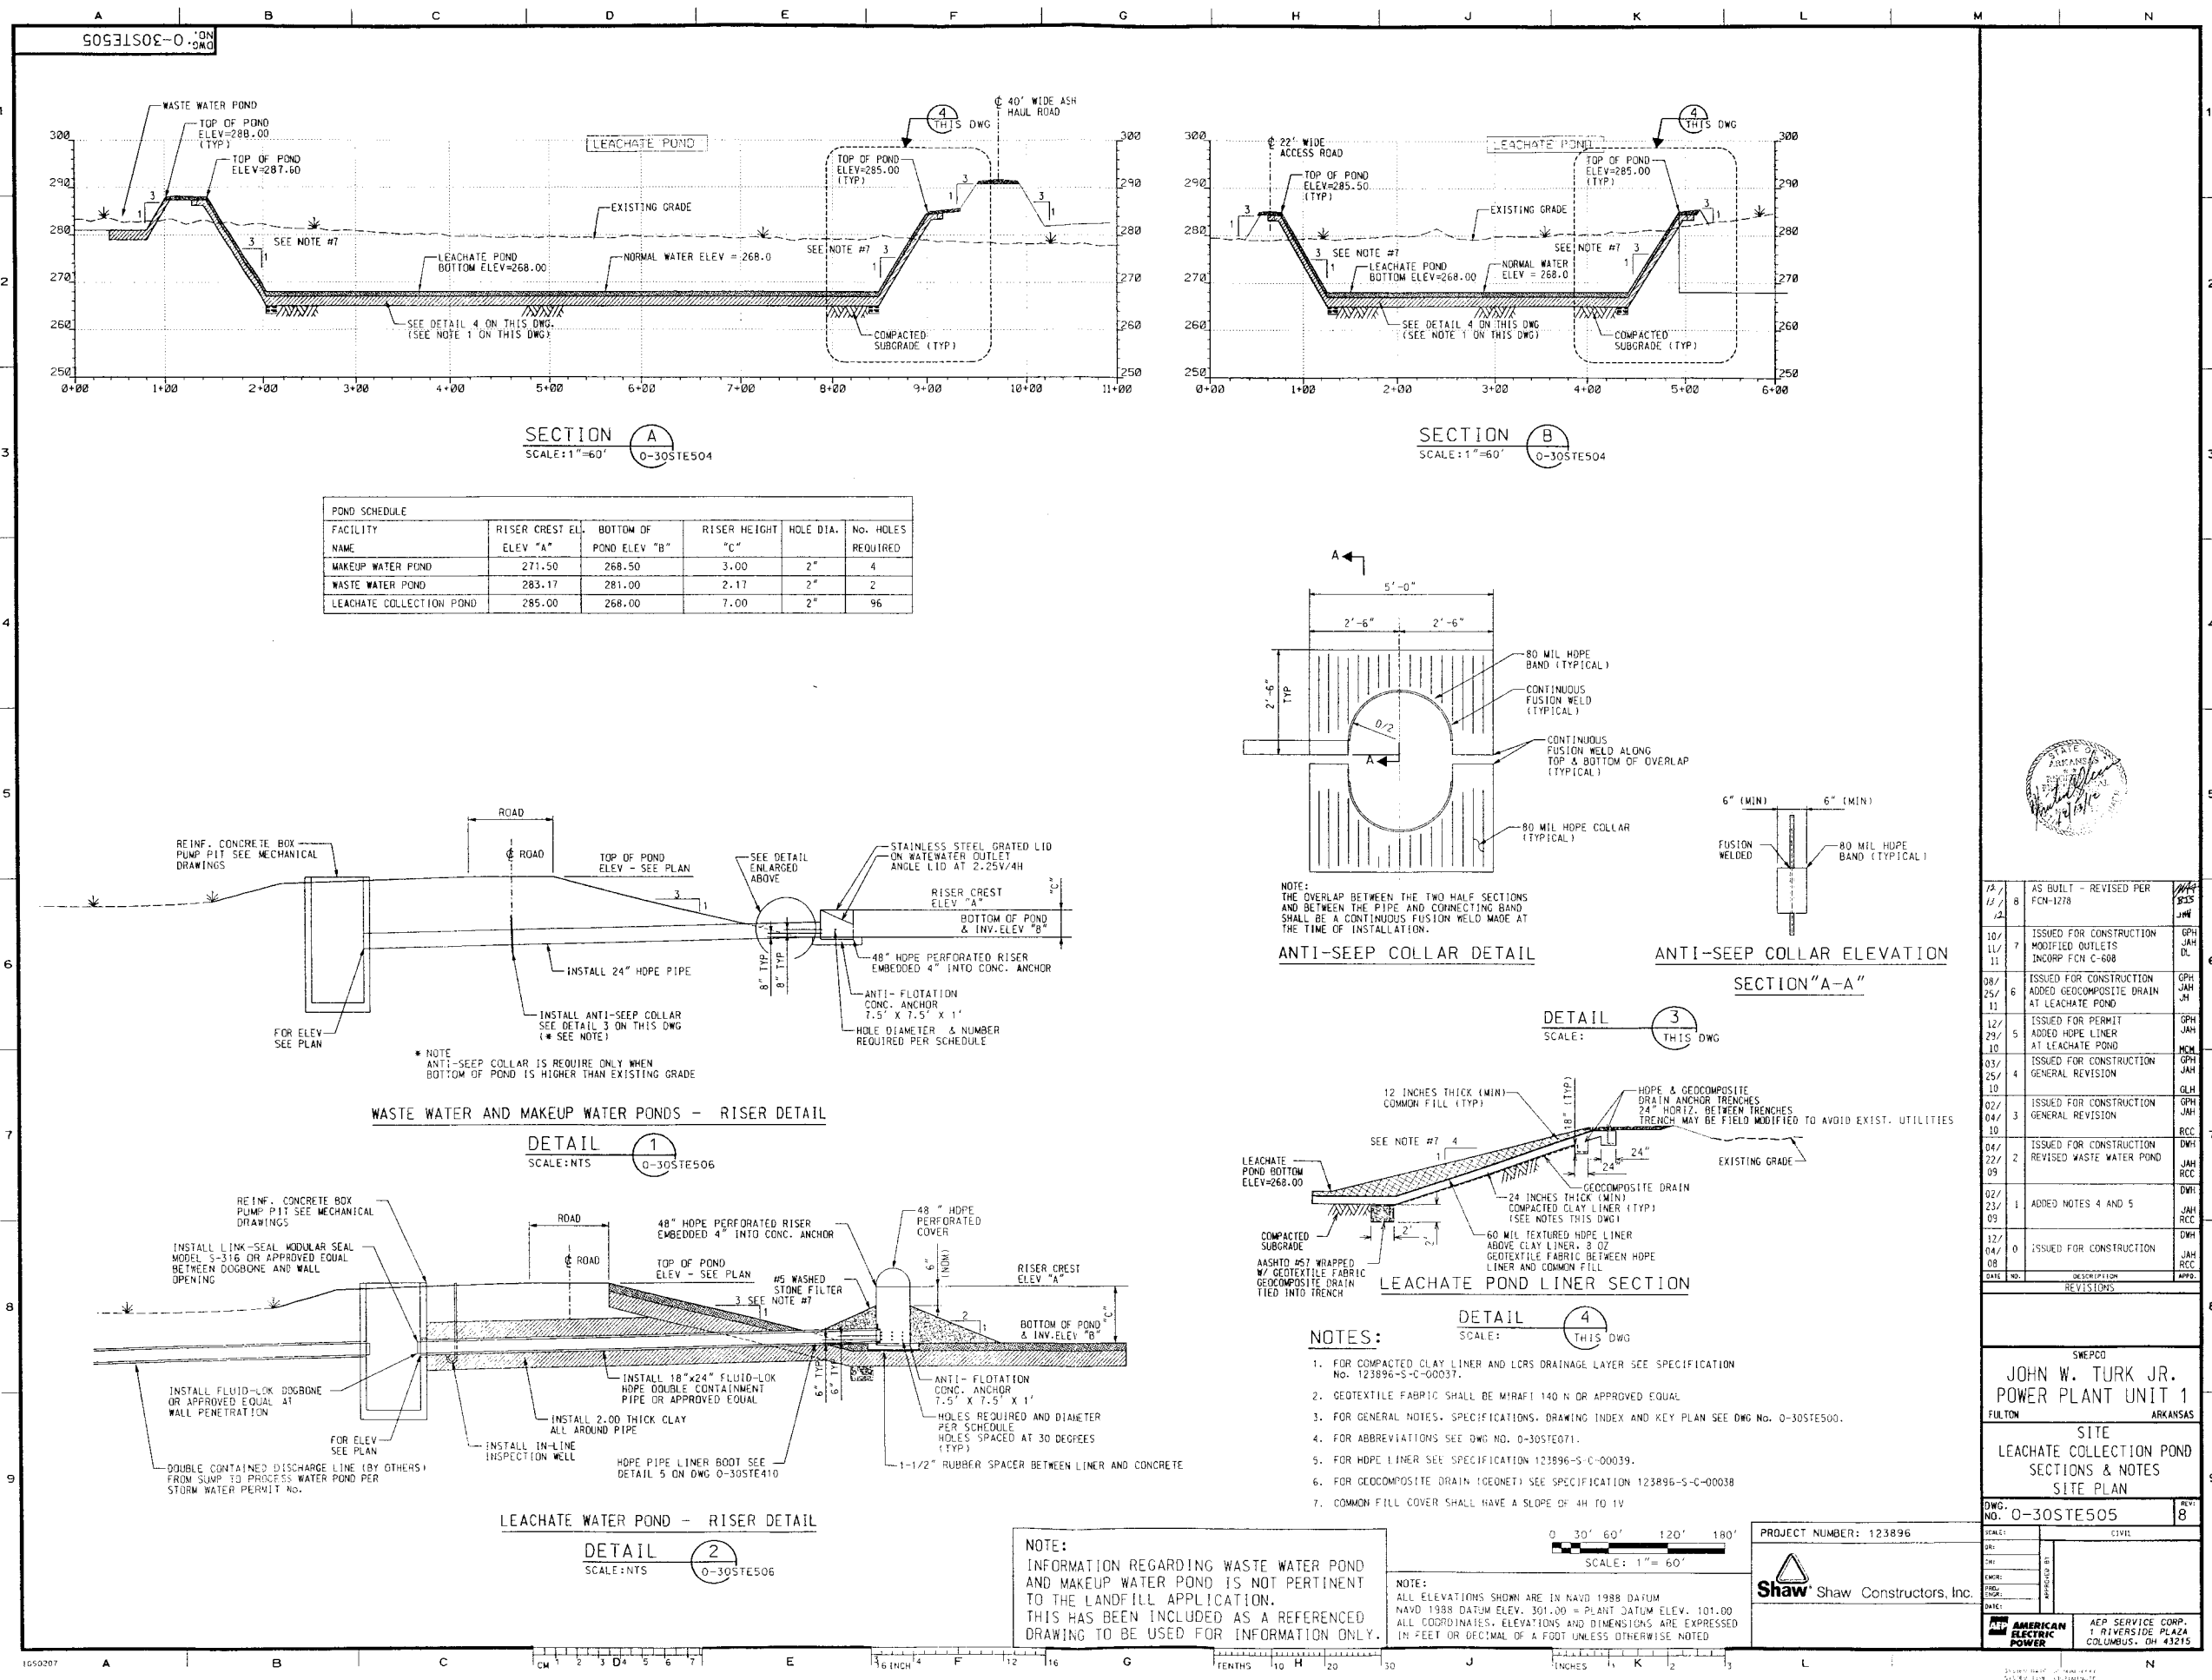


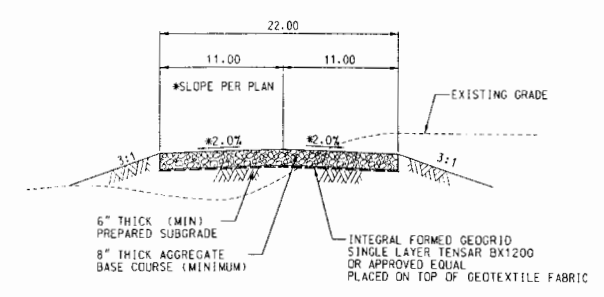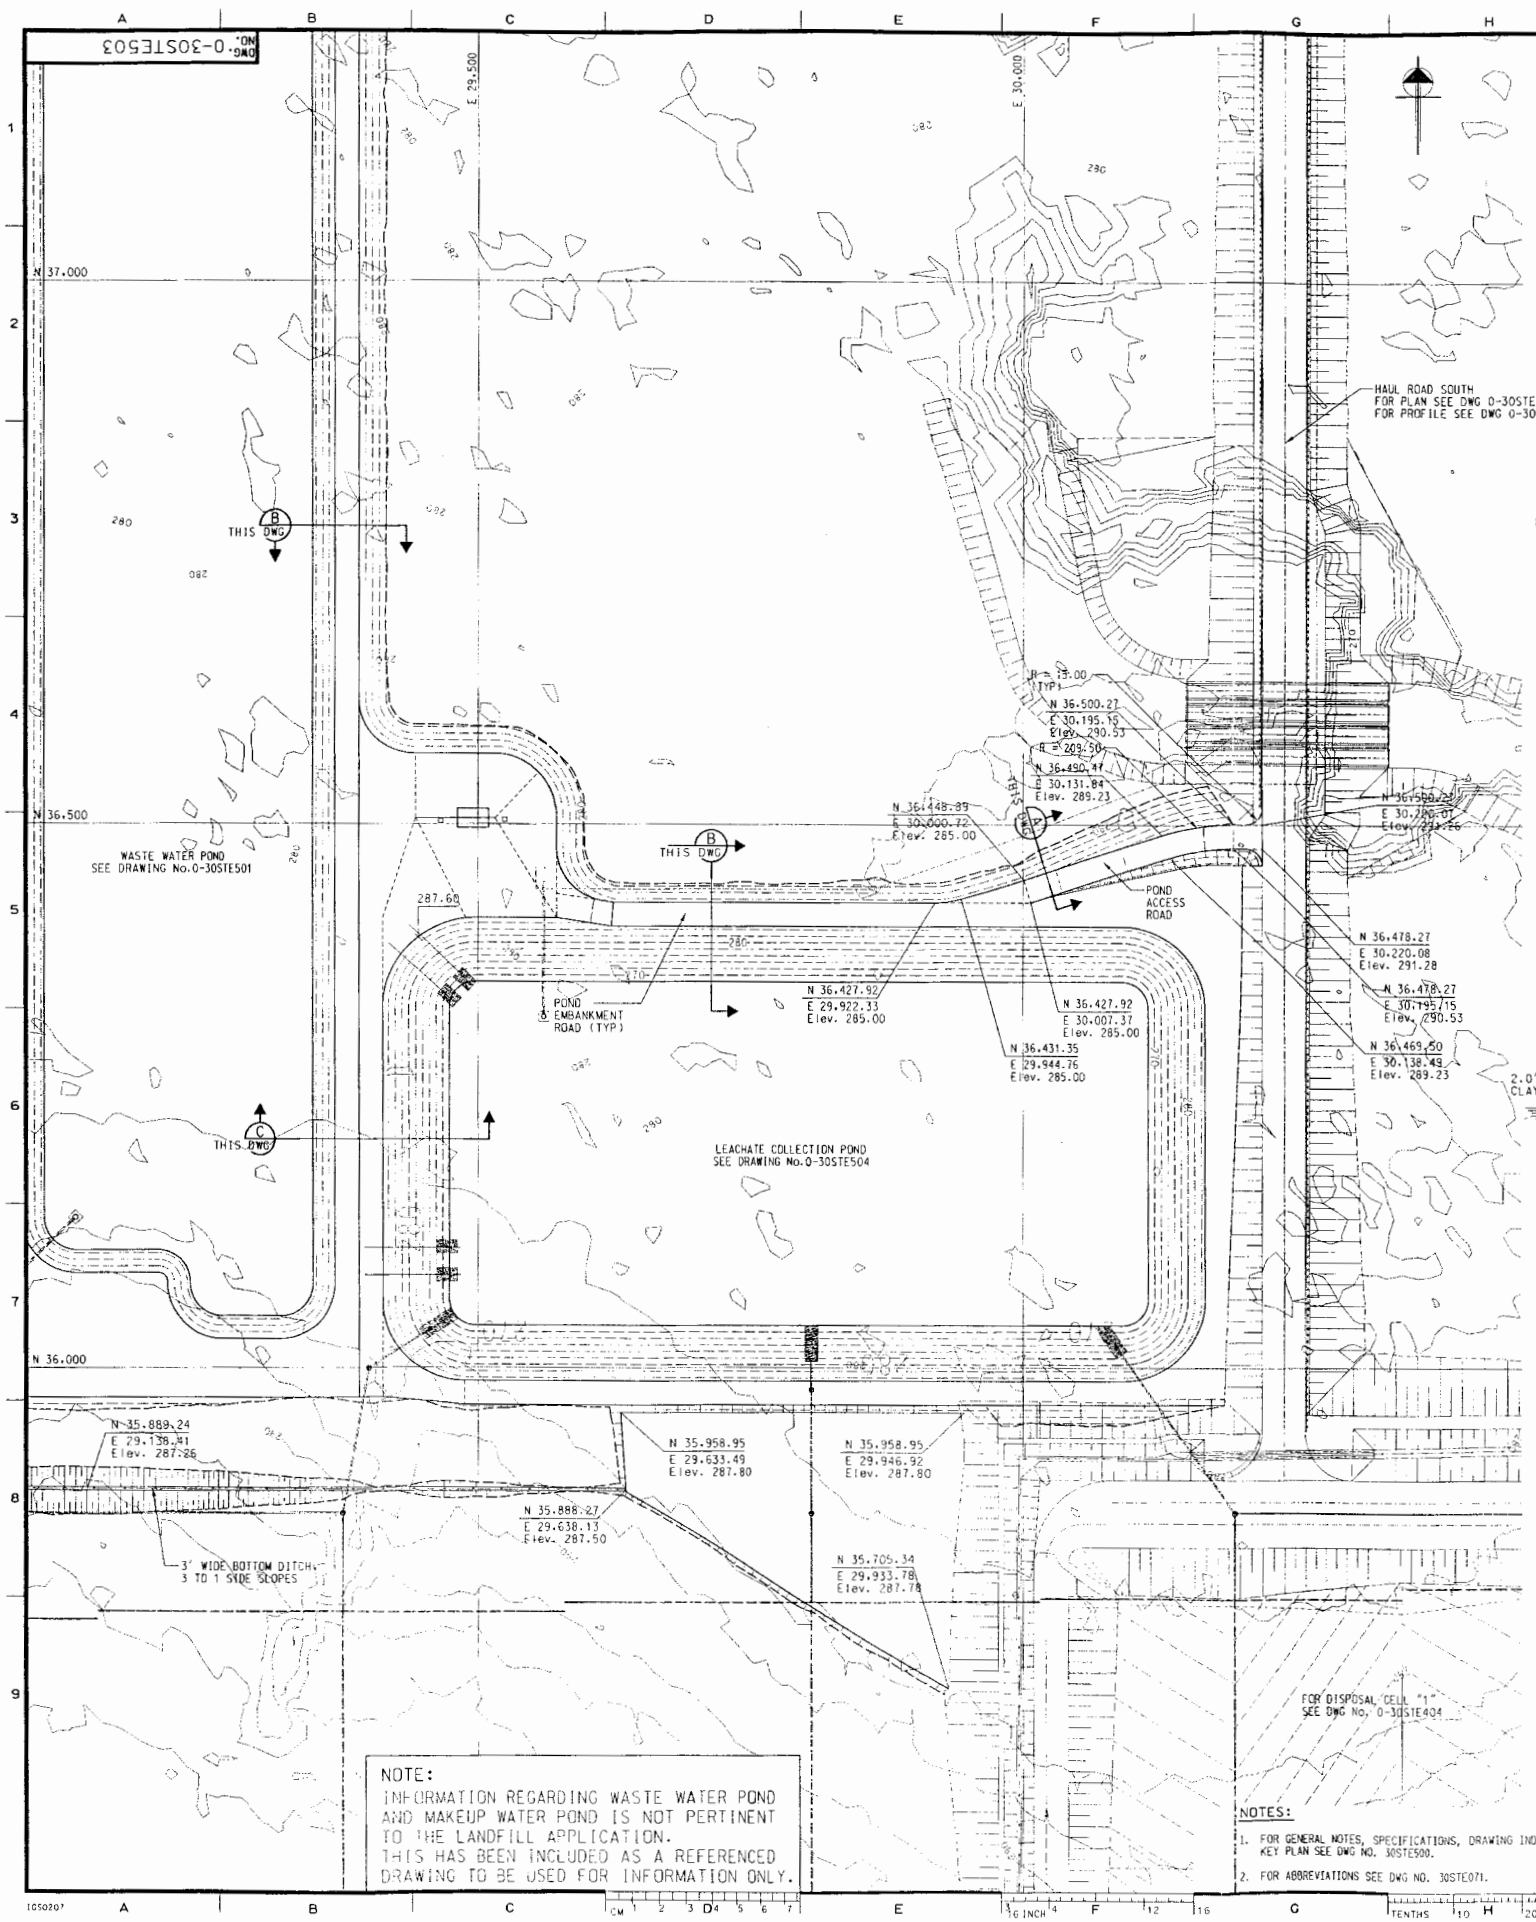


POND ACCESS ROAD - TYPE 4 (CLASS III)
SECTION A
SCALE: N.T.S. 0-30STE500 THRU 506

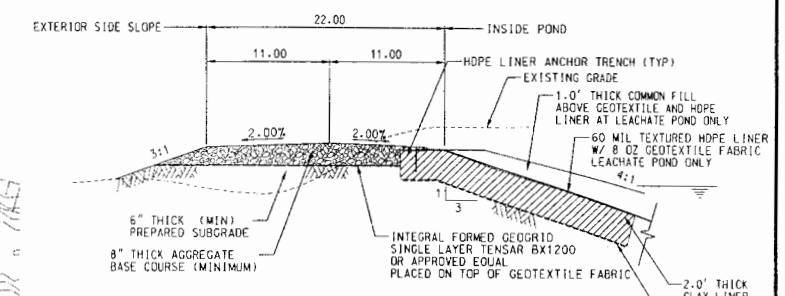


POND EMBANKMENT ROAD - TYPE 5 (CLASS III)
SECTION B
SCALE: N.T.S. 0-30STE500 THRU 506

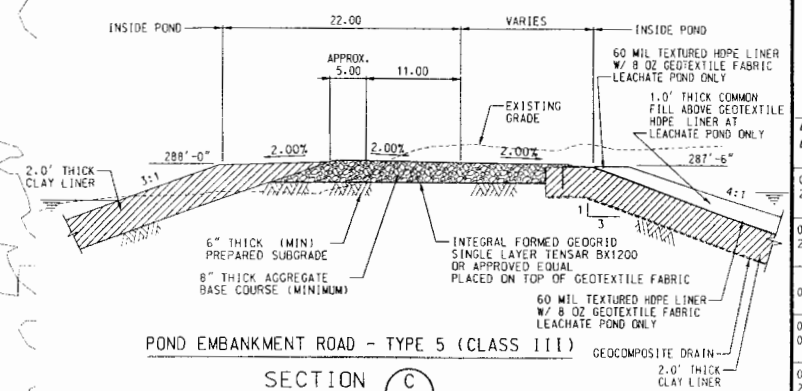

POND EMBANKMENT ROAD - TYPE 5 (CLASS III)
SECTION C
SCALE: N.T.S. 0-30STE500 THRU 506

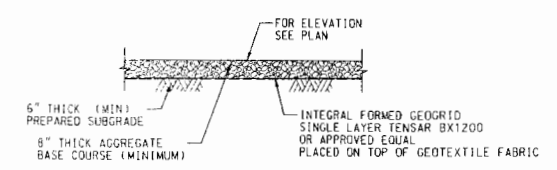

 AGGREGATE SURFACING
SECTION D
SCALE: N.T.S. 0-30STE500 THRU 506



NOTES:
1. FOR GENERAL NOTES, SPECIFICATIONS, DRAWING INDEX AND KEY PLAN SEE DWG NO. 30STE500.
2. FOR ABBREVIATIONS SEE DWG NO. 30STE001.

NOTE:
ALL ELEVATIONS SHOWN ARE IN NAVD 1988 DATUM
NAVD 1988 DATUM ELEV. 301.00 = PLANT DATUM ELEV. 101.00
ALL COORDINATES, ELEVATIONS AND DIMENSIONS ARE EXPRESSED IN FEET OR DECIMAL OF A FOOT UNLESS OTHERWISE NOTED

PROJECT NUMBER: 123896
Shaw Shaw Constructors, Inc.



DATE	NO.	DESCRIPTION	BY	APP'D
08/25/11	8	AS BUILT- REVISED PER DCN-C-0004, FCM-C-746 AND FCM-C-1085	JAH	BSS
08/25/11	7	ISSUED FOR CONSTRUCTION ADDED GEOCOMPOSITE DRAIN	JAH	DWH
02/29/10	6	ISSUED FOR PERMIT ADDED HOPE LINER	JAH	MCM
11/08/10	5	ISSUED FOR CONSTRUCTION ADDED DITCH AND FILL PAD	JAH	MCM
09/02/10	4	ISSUED FOR CONSTRUCTION REVISED SECTION B & C	JAH	FEL
03/25/10	3	ISSUED FOR CONSTRUCTION REVISED DWG BORDER	JAH	GLH
02/04/10	2	ISSUED FOR CONSTRUCTION GENERAL REVISION	JAH	RCC
04/22/09	1	ISSUED FOR CONSTRUCTION REVISED WASTE WATER POND	JAH	RCC
12/04/08	0	ISSUED FOR CONSTRUCTION	JAH	RCC

JOHN W. TURK JR.
POWER PLANT UNIT 1
FULTON ARKANSAS

SITE
MAKEUP WW & LEACHATE POND
ACCESS RD PLAN & SEC'S
SITE PLAN

DWG. NO. 0-30STE503
SCALE: CIVIL
PROJECT NUMBER: 123896
Shaw Shaw Constructors, Inc.
AMERICAN ELECTRIC POWER
AEP SERVICE CORP.
1 RIVERSIDE PLAZA
COLUMBUS, OH 43215